



at&t

AT&T SITE NUMBER: CCL06126
AT&T SITE NAME: CCL06126

INITIATIVE / PROJECT: NSB
USID: 298767
FA CODE: 15376635
RFDS ID: RFDS-89437
RFDS DATE: 11/08/2024
JOB ID: WSSFR0016626
PTN: 3701A0WFDV

3111 BENTON STREET
SANTA CLARA, CA 95051
JURISDICTION: CITY OF SANTA CLARA
APN: 290-27-006

SITE TYPE: OUTDOOR
EQUIPMENT / LIGHT POLE

Issued For:

CCL06126
CCL06126

3111 BENTON STREET
SANTA CLARA, CA 95051

PREPARED FOR

at&t

5001 Executive Parkway
San Ramon, California 94583

Vendor:

COMPLETE
Wireless Consulting, Inc.

AT&T SITE NO: CCL06126
PROJECT NO: -
DRAWN BY: T.T.
CHECKED BY: J. GRAY
APPROVED BY: -

ISSUE STATUS			
0	11/15/24	ZD 95%	T.T.
REV	DATE	DESCRIPTION	CAD

Licensee:

PRELIMINARY:
NOT FOR
CONSTRUCTION

KEVIN R. SORENSEN
S4469

IT IS A VIOLATION OF LAW FOR ANY PERSON,
UNLESS THEY ARE ACTING UNDER THE
DIRECTION OF A LICENSED PROFESSIONAL
ENGINEER, TO ALTER THIS DOCUMENT.

ENGINEER:

Streamline Engineering
amquestum lnc.
3843 Taylor Road, Suite A, Loomis, CA 95650
Contact: Kevin Sorenson Phone: 916-660-1930
E-Mail: kevin@streamlineeng.com Fax: 916-660-1941
THESE PLANS AND SPECIFICATIONS, AS INSTRUMENTS OF SERVICE, ARE AND SHALL REMAIN THE PROPERTY OF STREAMLINE ENGINEERING AND DESIGN, INC. (SED). NO PART OF THESE PLANS OR SPECIFICATIONS SHALL BE REPRODUCED, COPIED, OR TRANSMITTED IN ANY FORM OR BY ANY MEANS, WITHOUT THE WRITTEN PERMISSION OF SED. ENGINEER: Copyright 2024, STREAMLINE ENGINEERING AND DESIGN, INC. ALL RIGHTS RESERVED.

SHEET TITLE:

TITLE SHEET


SHEET NUMBER:

T-1.1

PROJECT DESCRIPTION

- A (N) AT&T UNMANNED TELECOMMUNICATION FACILITY CONSISTING OF INSTALLING:
- (N) EQUIPMENT LEASE AREA W/ (N) GROUND MOUNTED EQUIPMENT CABINETS & (N) UTILITIES TO (N) SITE LOCATION.
 - (3) (N) LIGHT POLES W/ (N) ANTENNAS & ANTENNA EQUIPMENT.

VICINITY MAP

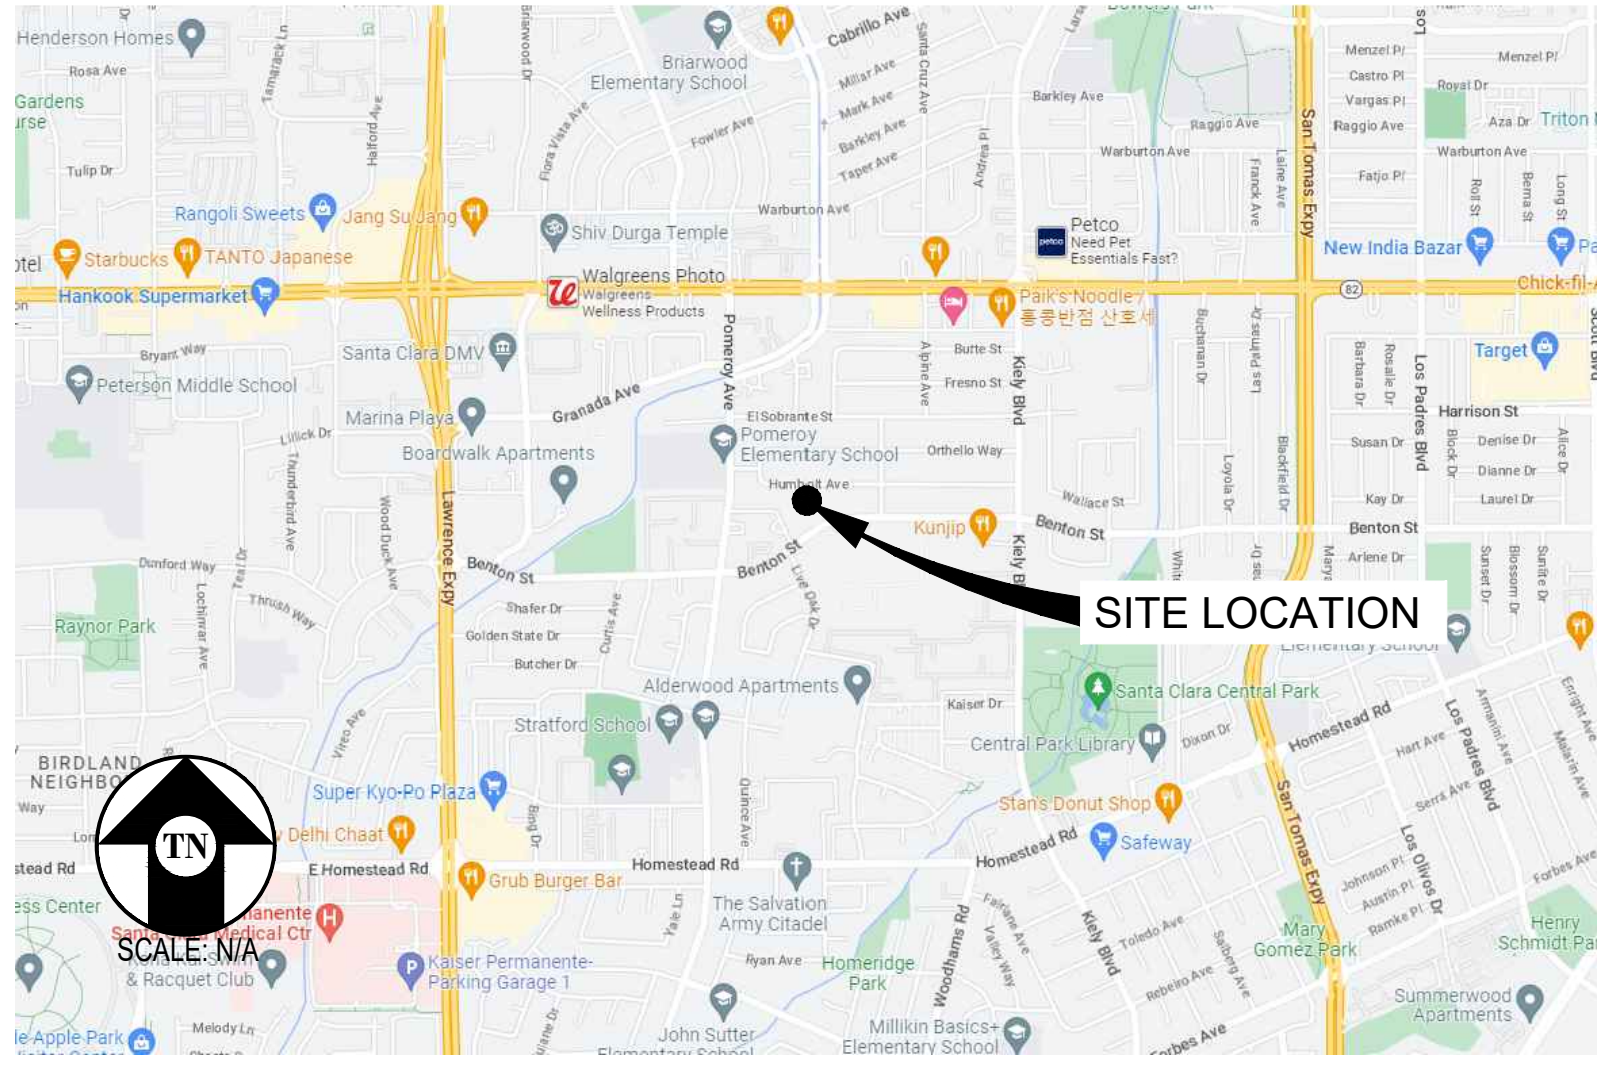

DRIVING DIRECTIONS

- FROM: 5001 EXECUTIVE PARKWAY, SAN RAMON, CA 94583
TO: 3111 BENTON STREET, SANTA CLARA, CA 95051
- | | |
|--|---------|
| 1. HEAD SOUTHWEST | 33 FT |
| 2. TURN RIGHT | 12 FT |
| 3. TURN LEFT TOWARD EXECUTIVE PKWY | 164 FT |
| 4. TURN RIGHT TOWARD EXECUTIVE PKWY | 295 FT |
| 5. TURN RIGHT ONTO EXECUTIVE PKWY | 0.2 MI |
| 6. TURN RIGHT ONTO CAMINO RAMON | 0.6 MI |
| 7. USE THE RIGHT 2 LANES TO TURN RIGHT ONTO BOLLINGER CANYON RD | 0.5 MI |
| 8. USE THE RIGHT LANE TO MERGE ONTO I-680 S VIA THE RAMP TO SAN JOSE | 0.3 MI |
| 9. MERGE ONTO I-680 S | 27.8 MI |
| 10. TAKE EXIT 6 FOR MONTAGUE EXPWY | 0.4 MI |
| 11. MERGE ONTO MONTAGUE EXPWY | 5.8 MI |
| 12. CONTINUE ONTO SAN TOMAS EXPWY | 2.5 MI |
| 13. TURN RIGHT ONTO BENTON ST | 0.8 MI |
| 14. TURN LEFT | 0.0 MI |
- END AT: 3111 BENTON STREET, SANTA CLARA, CA 95051
- ESTIMATED TIME: 1 HOUR ESTIMATED DISTANCE: 38.8 MILES

CODE COMPLIANCE

ALL WORK & MATERIALS SHALL BE PERFORMED & INSTALLED IN ACCORDANCE WITH THE CURRENT EDITIONS OF THE FOLLOWING CODES AS ADOPTED BY THE LOCAL GOVERNING AUTHORITIES. NOTHING IN THESE PLANS IS TO BE CONSTRUED TO PERMIT WORK NOT CONFORMING TO THESE CODES:

- 2022 CALIFORNIA ADMINISTRATIVE CODE, PART 1, TITLE 24 C.C.R.
 - 2022 CALIFORNIA BUILDING CODE (CBC), PART 2, VOLUME 1&2, TITLE 24 C.C.R. (2021 INTERNATIONAL BUILDING CODE AND 2022 CALIFORNIA AMENDMENTS)
 - 2022 CALIFORNIA ELECTRICAL CODE (CEC), PART 3, TITLE 24 C.C.R. (2020 NATIONAL ELECTRICAL CODE AND 2022 CALIFORNIA AMENDMENTS)
 - 2022 CALIFORNIA MECHANICAL CODE (CMC) PART 4, TITLE 24 C.C.R. (2021 UNIFORM MECHANICAL CODE AND 2022 CALIFORNIA AMENDMENTS)
 - 2022 CALIFORNIA PLUMBING CODE (CPC), PART 5, TITLE 24 C.C.R. (2021 UNIFORM PLUMBING CODE AND 2022 CALIFORNIA AMENDMENTS)
 - 2022 CALIFORNIA ENERGY CODE (CEC), PART 6, TITLE 24 C.C.R.
 - 2022 CALIFORNIA FIRE CODE, PART 9, TITLE 24 C.C.R. (2021 INTERNATIONAL FIRE CODE AND 2022 CALIFORNIA AMENDMENTS)
 - 2022 CALIFORNIA GREEN BUILDING STANDARDS CODE, PART 11, TITLE 24 C.C.R.
 - 2022 CALIFORNIA REFERENCED STANDARDS, PART 12, TITLE 24 C.C.R.
- ANSI/EIA-TIA-222-H

ALONG WITH ANY OTHER APPLICABLE LOCAL & STATE LAWS AND REGULATIONS

DISABLED ACCESS REQUIREMENTS



THIS FACILITY IS UNMANNED & NOT FOR HUMAN HABITATION. DISABLED ACCESS & REQUIREMENTS ARE NOT REQUIRED IN ACCORDANCE WITH CALIFORNIA STATE BUILDING CODE, TITLE 24 PART 2, SECTION 11B-203.5

SHEET INDEX


SHEET	DESCRIPTION	REV	SHEET	DESCRIPTION	REV
T-1.1	TITLE SHEET	-			
C-1	TOPOGRAPHIC SURVEY	-			
C-2	TOPOGRAPHIC SURVEY	-			
A-1.1	OVERALL SITE PLAN	-			
A-1.2	ENLARGED SITE PLAN	-			
A-1.3	ENLARGED SITE PLAN	-			
A-1.4	EQUIPMENT PLAN	-			
A-2.1	ANTENNA PLANS	-			
A-2.2	ANTENNA SCHEDULE	-			
A-3.1	ELEVATIONS	-			
A-3.2	ELEVATIONS	-			
A-4.1	ANTENNA DETAILS	-			
A-4.2	EQUIPMENT DETAILS	-			
E-1.1	ELECTRICAL PLAN	-			

OWNER(S): SANTA CLARA FIRST BAPTIST CHURCH
3111 BENTON STREET
SANTA CLARA, CA 95051

ELEVATION of Ground at Structure (NAVD88) 94' AMSL

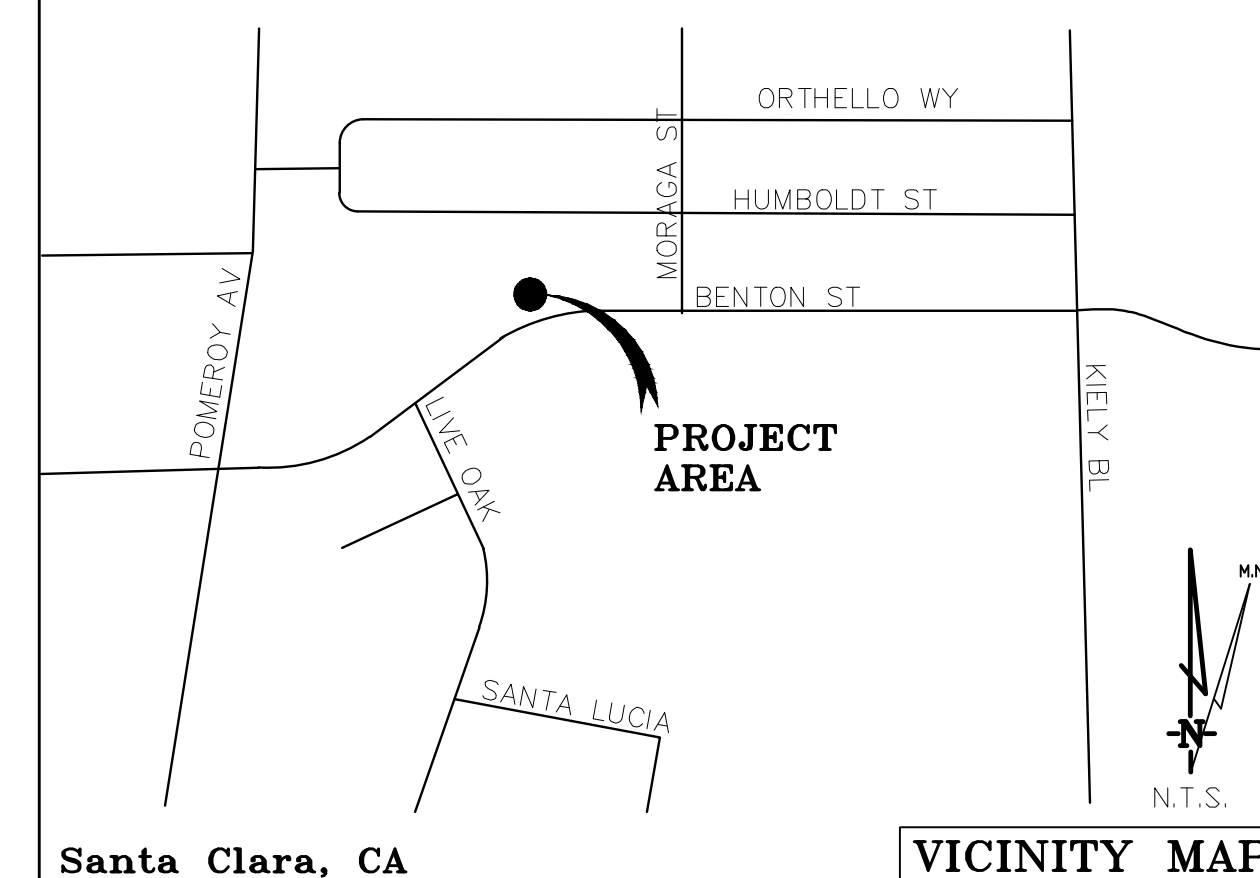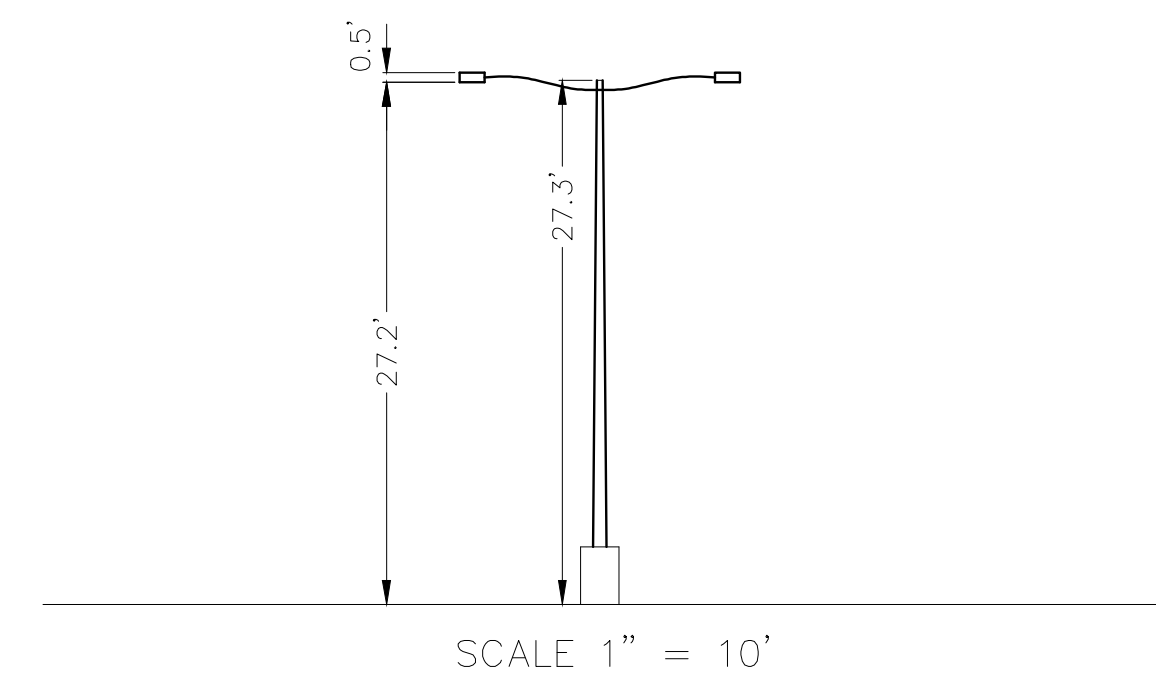


BOUNDARY SHOWN IS BASED ON MONUMENTATION FOUND AND RECORD INFORMATION. THIS IS NOT A BOUNDARY SURVEY. THIS IS A SPECIALIZED TOPOGRAPHIC AND PROPERTY LINES AND EASEMENTS DRAWING. A GRAPHIC DEPICTION BASED ON INFORMATION GATHERED FROM VARIOUS SOURCES OF RECORD AND AVAILABLE MONUMENTATION FOUND DURING THE FIELD SURVEY. NO EASEMENTS WERE RESEARCHED OR PLOTTED. PROPERTY LINES AND LINES OF TITLE WERE NOT INVESTIGATED NOR SURVEYED. NO PROPERTY MONUMENTS WERE SET.

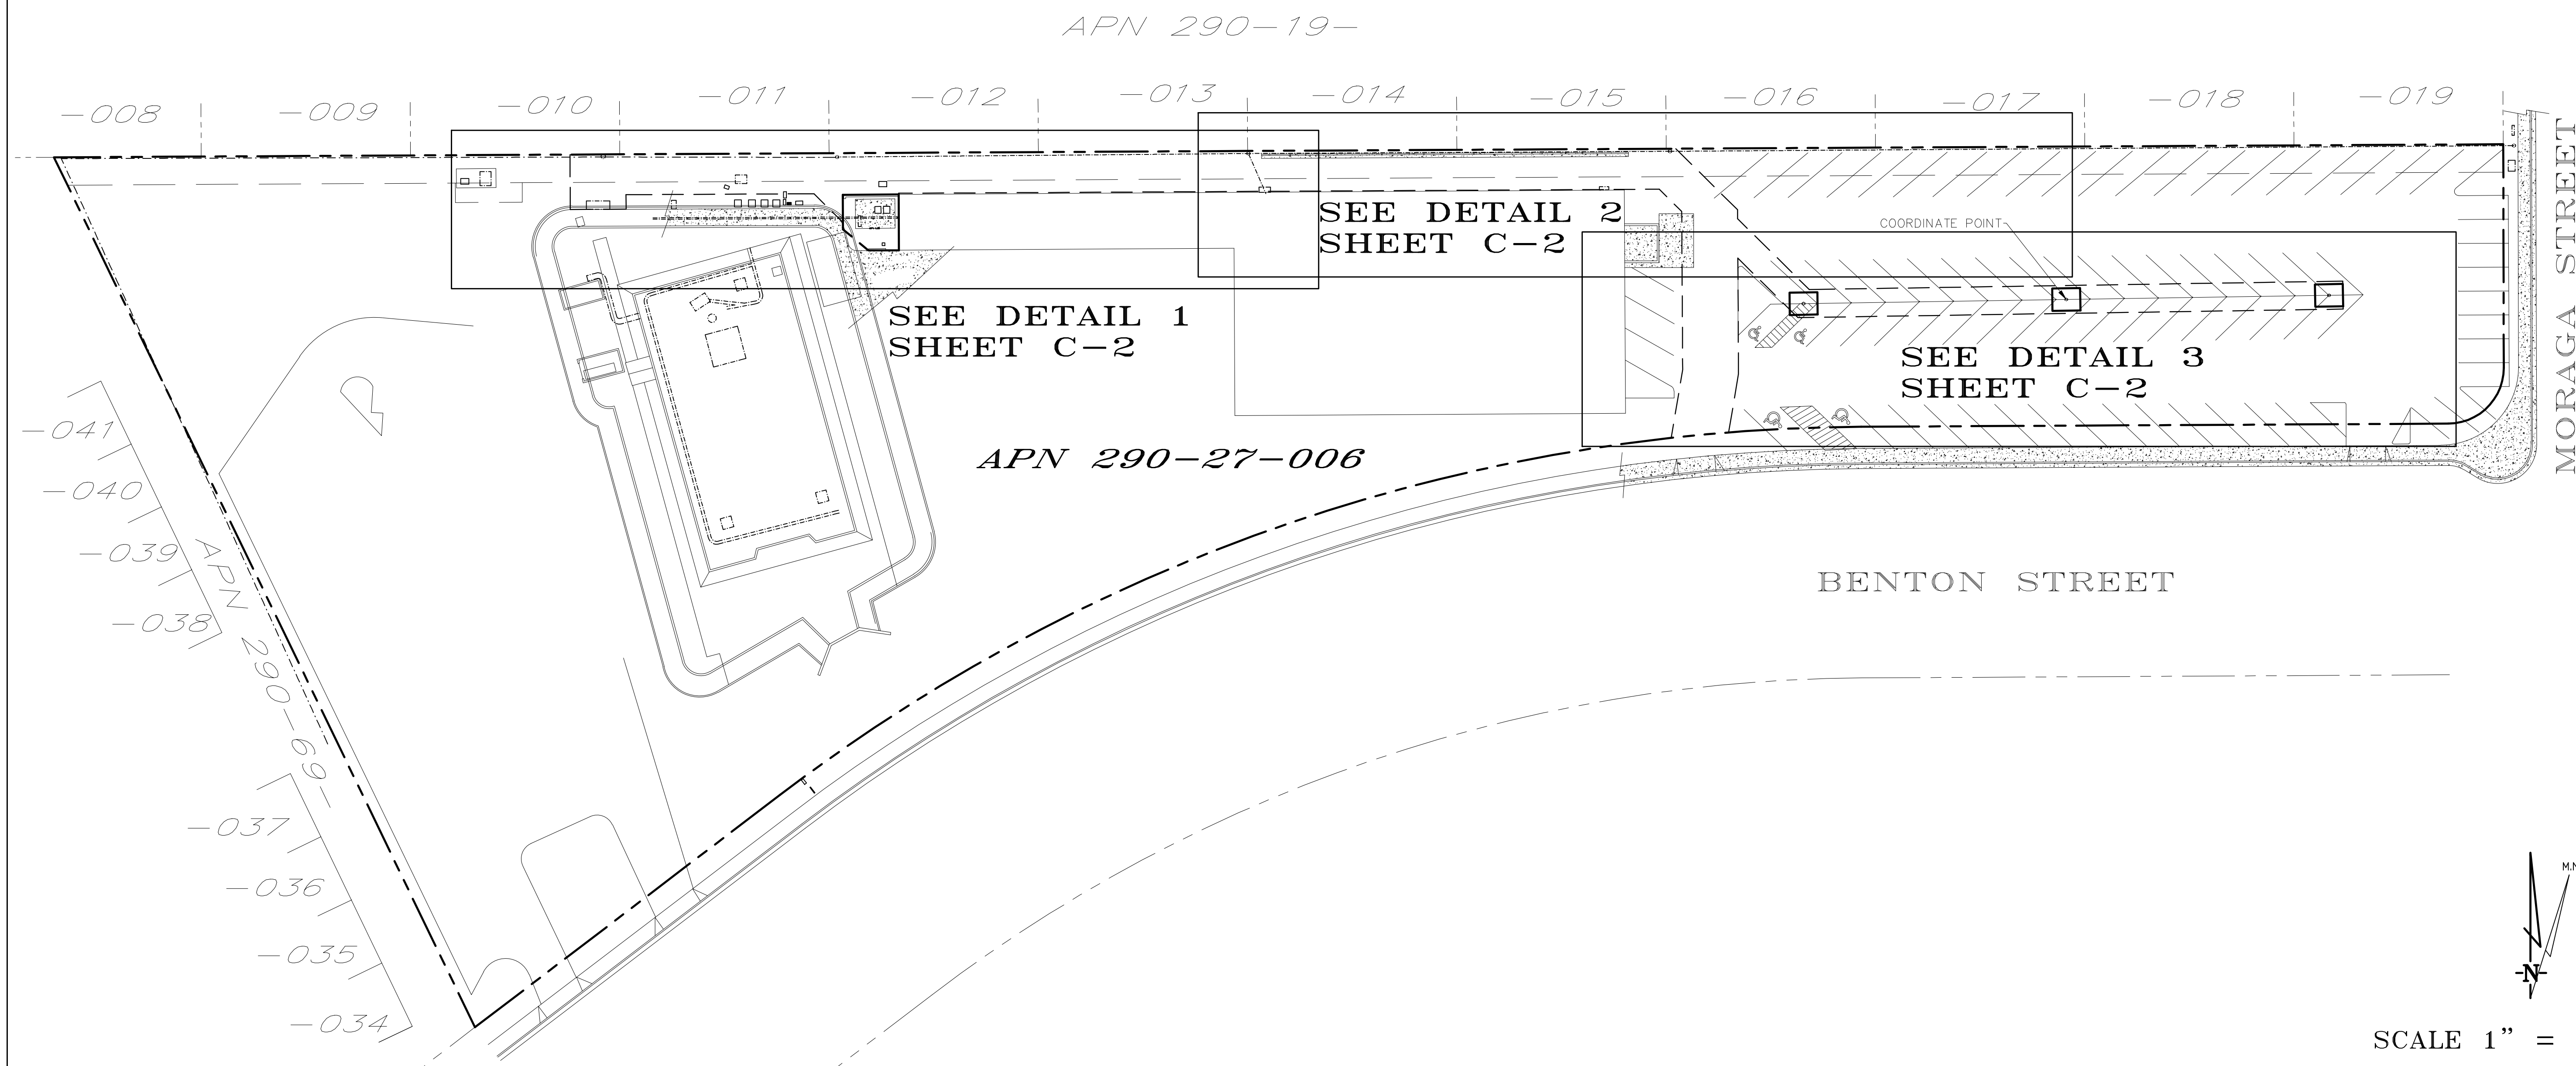[illegible]

SCALE 1" = 30'

OVERALL PROJECT AREA

Surveyor

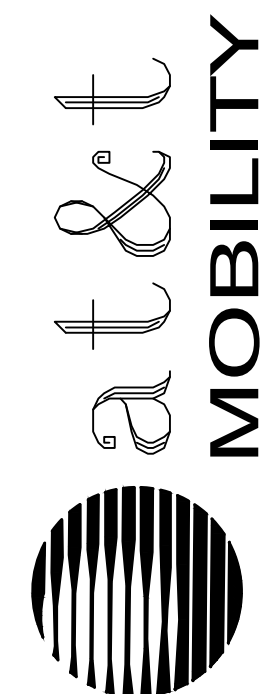


CCL06126
3111 Benton Street
Santa Clara, CA 95051


PLOT PLAN AND
SITE TOPOGRAPHY

[illegible]


C-1

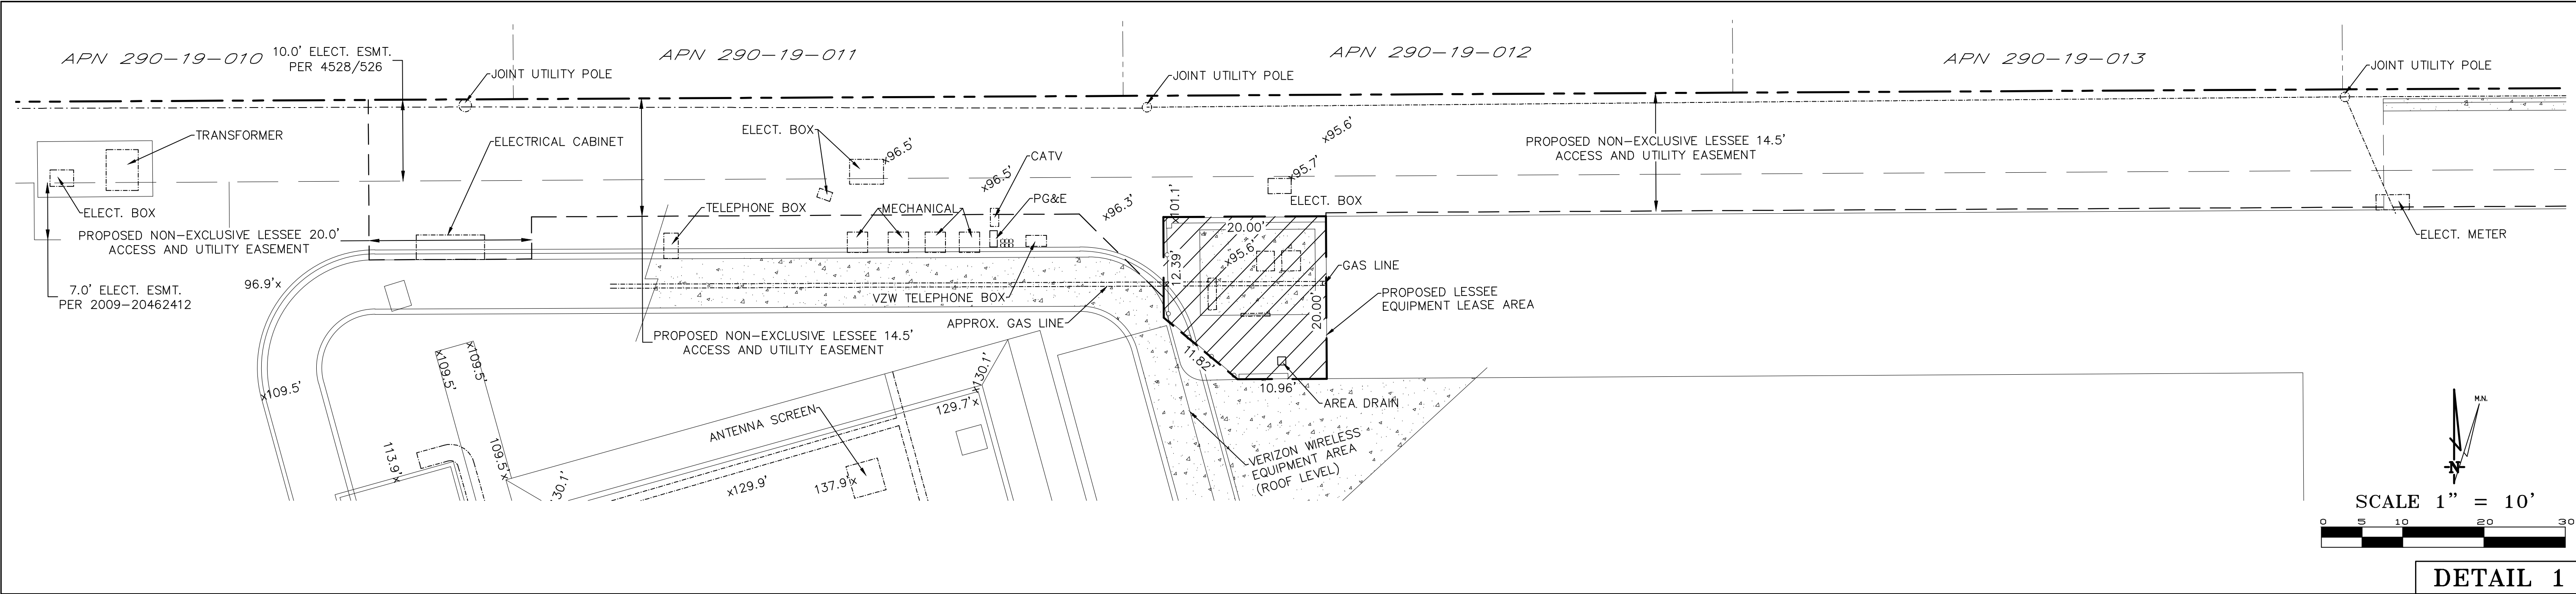

DETAIL 1

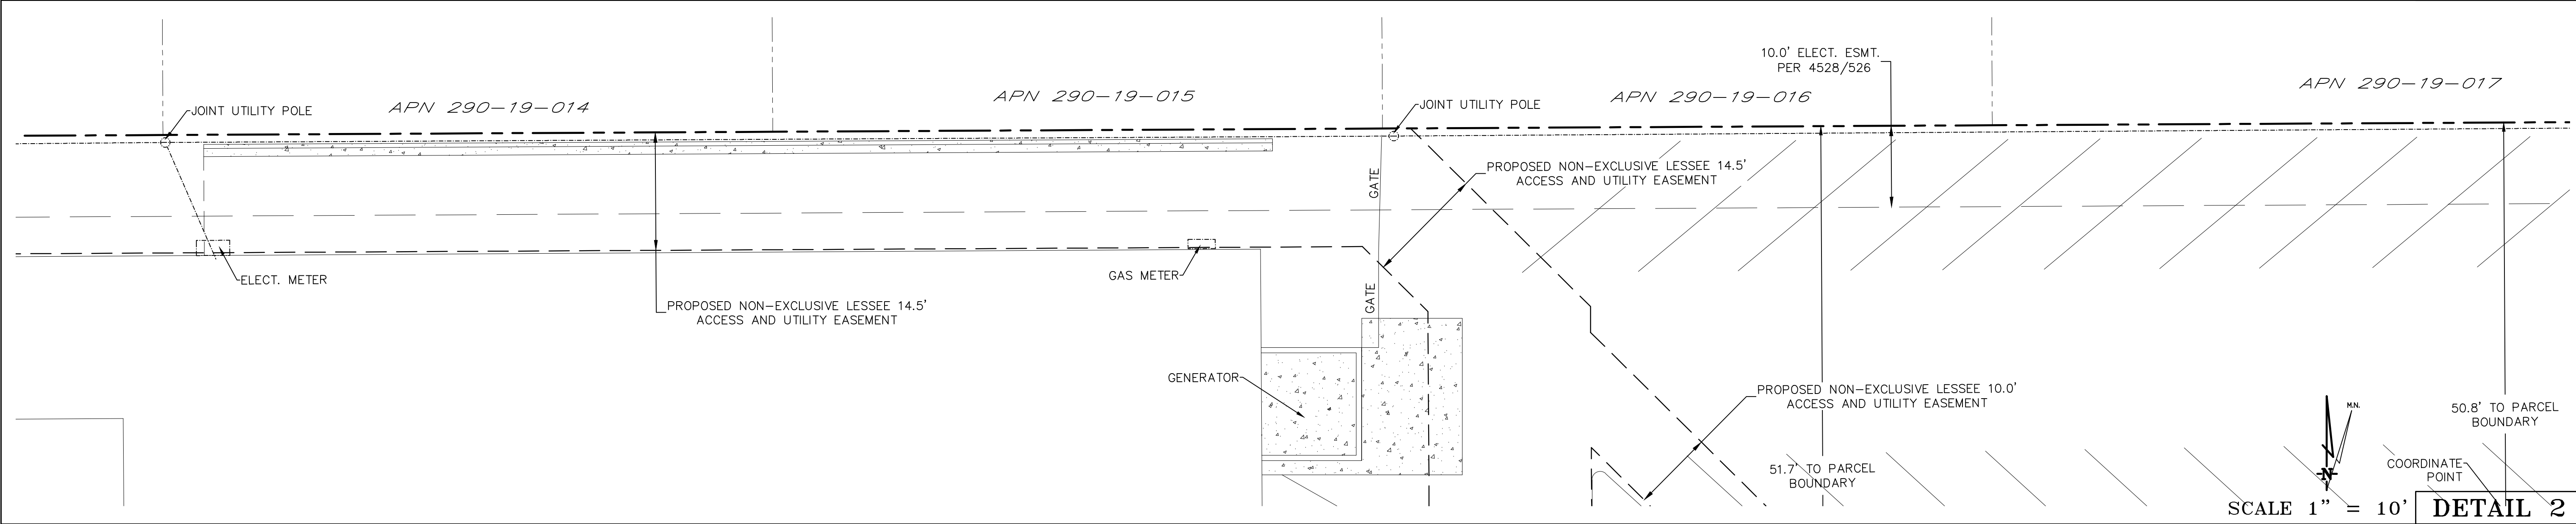

DETAIL 2

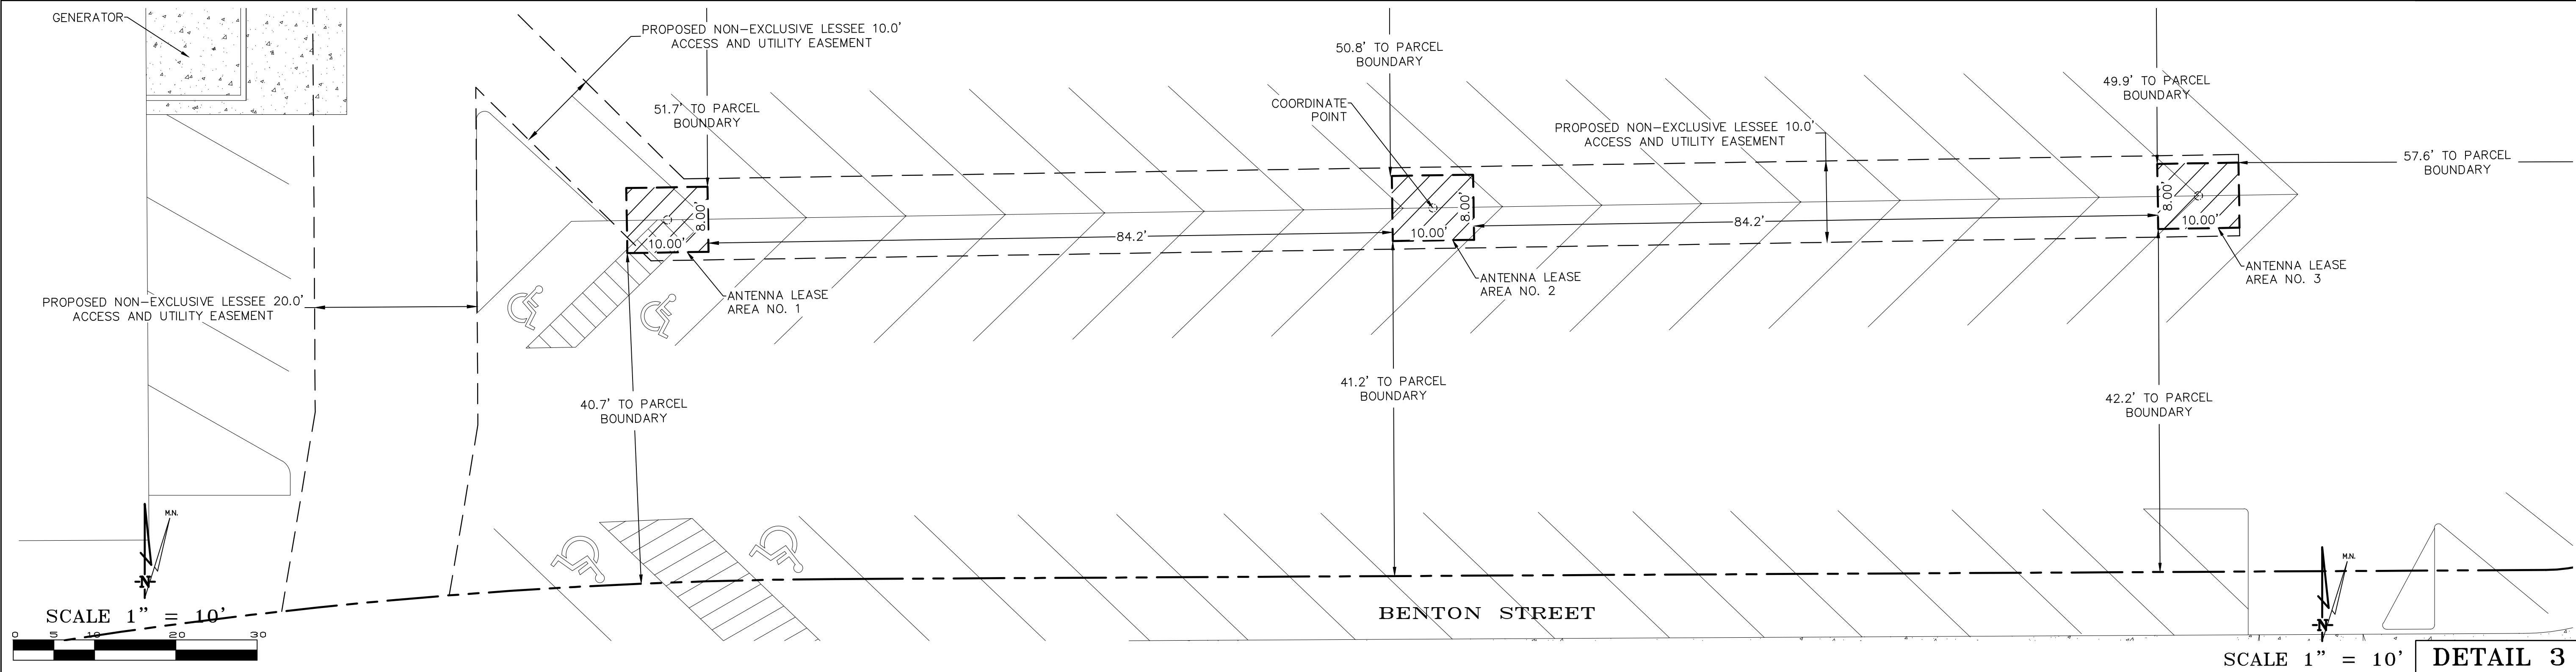

DETAIL 3

DEPT	APPROVED	DATE
A&C		
RE		
RF		
INT		
EE\IN		
OPS		
EE\OUT		

Surveyor

GEIL ENGINEERING
ENGINEERING • SURVEYING • PLANNING
1226 HIGH STREET
AUBURN, CALIFORNIA 96603
Phone: (916) 830-3426
Fax: (916) 830-1309


at&t
MOBILITY

CCL06126
3111 Benton Street
Santa Clara, CA 95051

PLOT PLAN AND
SITE TOPOGRAPHY

Sheet

C-2

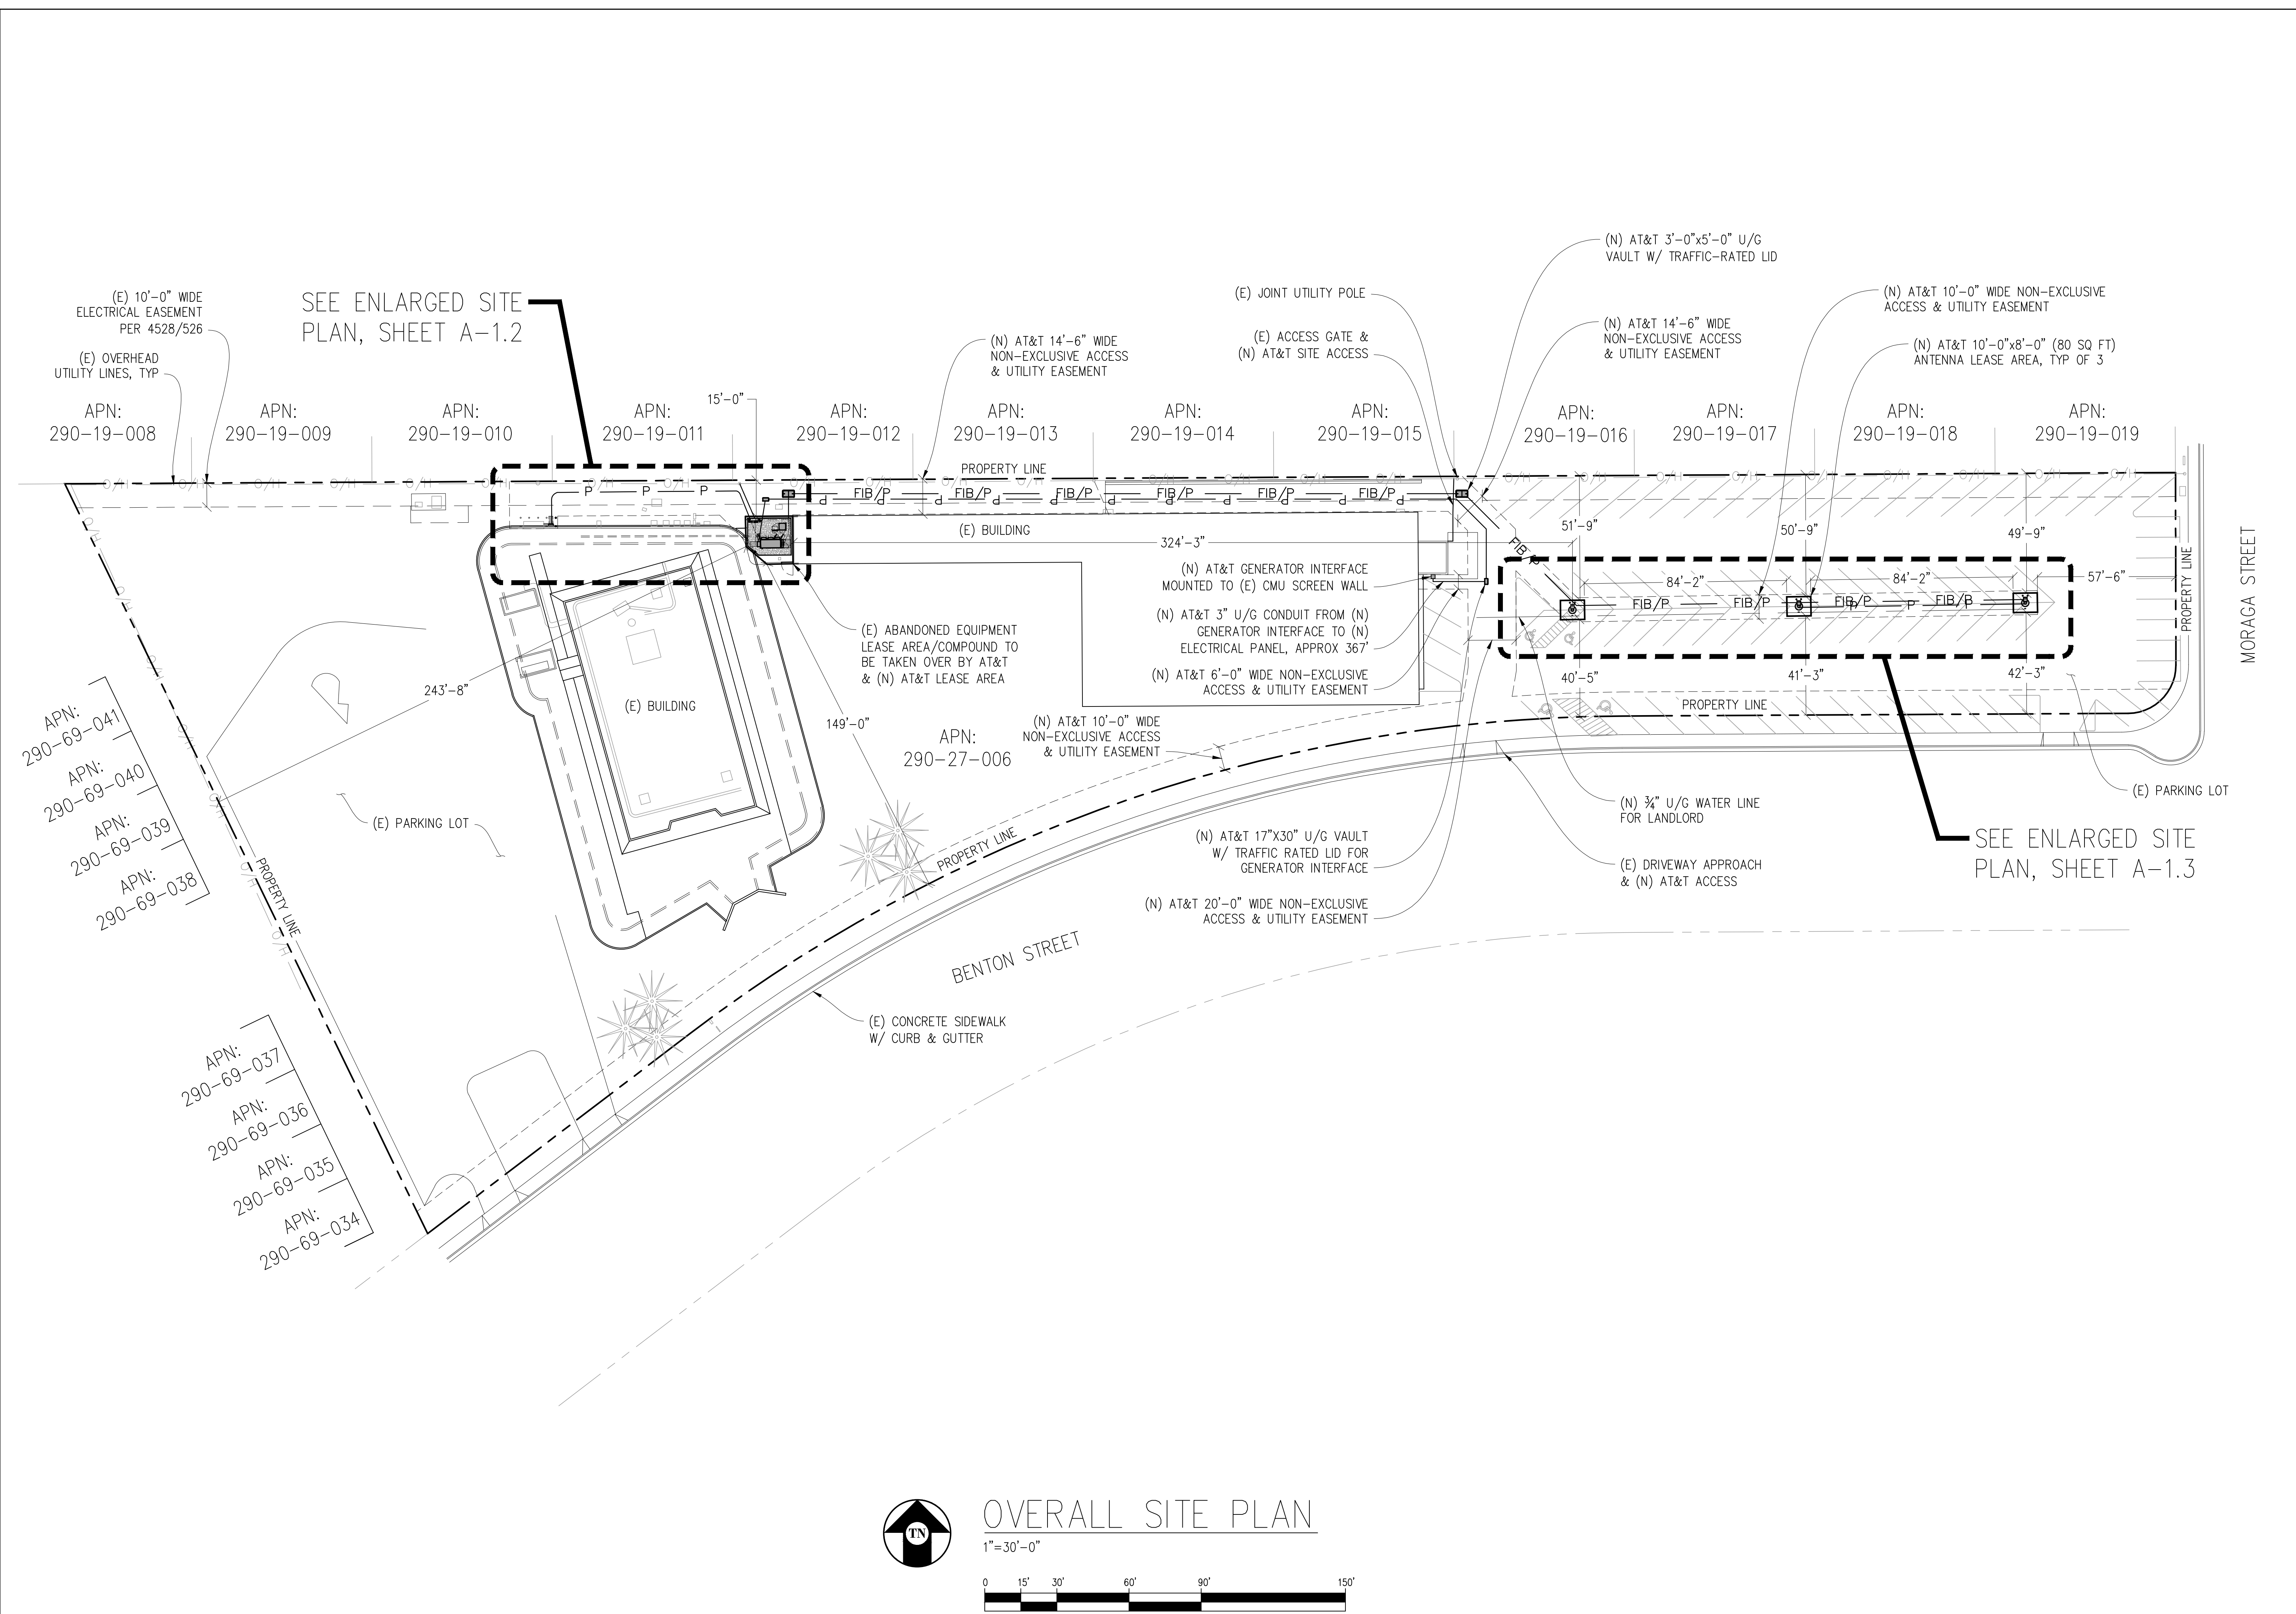

Issued For:

CCL06126
CCL06126

3111 BENTON STREET
SANTA CLARA, CA 95051

PREPARED FOR

at&t

5001 Executive Parkway
San Ramon, California 94583

Vendor:

COMPLETE
Wireless Consulting, Inc.

AT&T SITE NO:

CCL06126

PROJECT NO:

-

DRAWN BY:

T.T.

CHECKED BY:

J. GRAY

APPROVED BY:

-

ISSUE STATUS			
REV	DATE	DESCRIPTION	CAD
0	11/15/24	ZD 90%	T.T.

Licensee:

PRELIMINARY:
NOT FOR
CONSTRUCTION

KEVIN R. SORENSEN
S4469

IT IS A VIOLATION OF LAW FOR ANY PERSON,
UNLESS THEY ARE ACTING UNDER THE
DIRECTION OF A LICENSED PROFESSIONAL
ENGINEER, TO ALTER THIS DOCUMENT.

ENGINEER:



Streamline Engineering
3843 Taylor Road, Suite A, Lodi, CA 95650
Contact: Kevin Sorensen Phone: 916-660-1830
E-Mail: kevin@streamlineeng.com Fax: 916-660-1941
THESE PLANS AND SPECIFICATIONS ARE INSTRUMENTS OF SERVICE, AND SHALL REMAIN THE PROPERTY OF STREAMLINE ENGINEERING AND DESIGN, INC. ANY REUSE OR REPRODUCTION OF THESE PLANS AND SPECIFICATIONS WITHOUT THE WRITTEN PERMISSION OF STREAMLINE ENGINEERING AND DESIGN, INC. IS STRICTLY PROHIBITED. Copyright 2025, Streamline Engineering and Design, Inc. All Rights Reserved.

SHEET TITLE:

OVERALL
SITE PLAN


SHEET NUMBER:

A-1.1

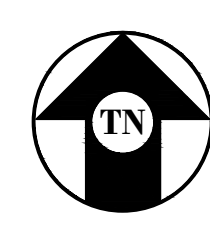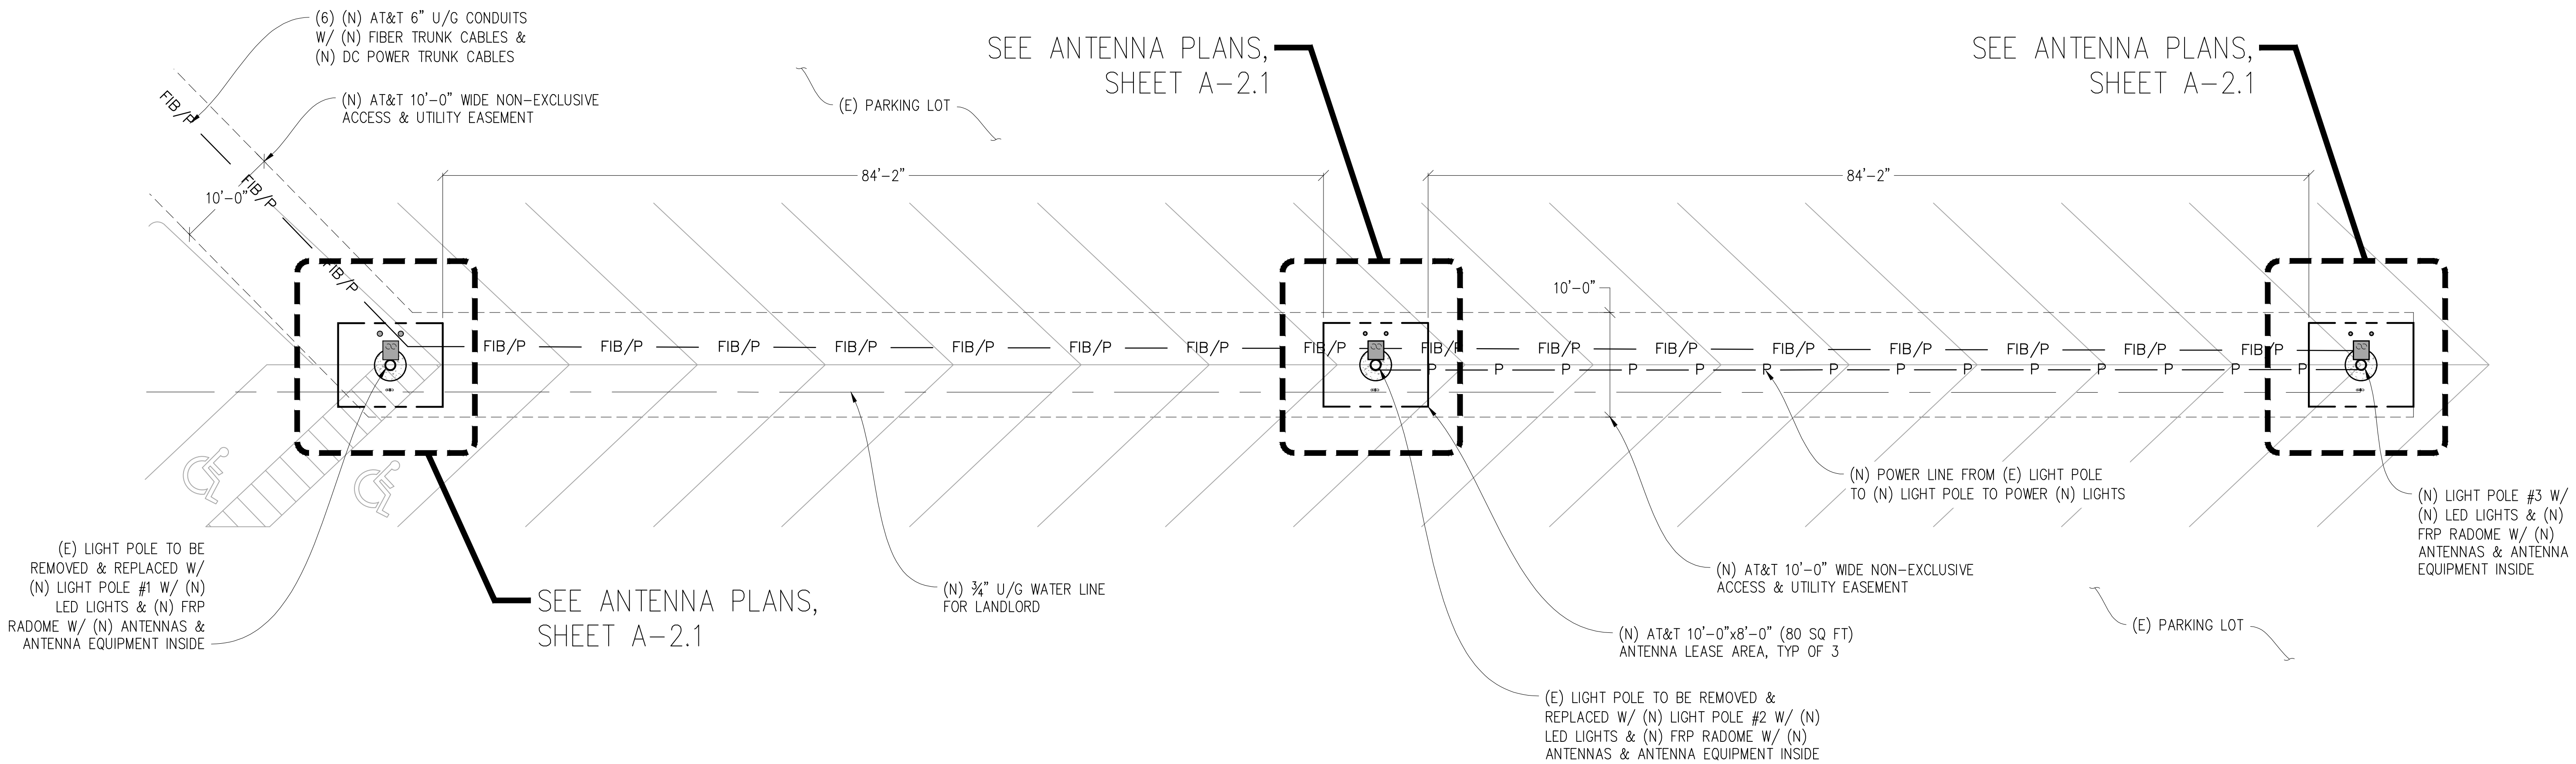

ENLARGED SITE PLAN

1/8"=1'-0"

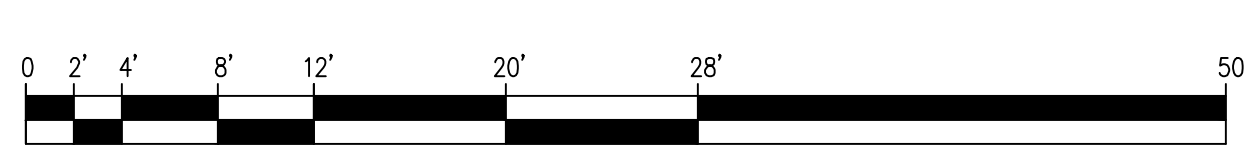

NOTE:
ALL (N) LIGHT POLES, LIGHT EXTENSION ARMS, LIGHT FIXTURES & (N) AT&T ANTENNAS, ANTENNA MOUNTS, ANTENNA EQUIPMENT & EXPOSED CABLES TO BE COVERED IN 3M FILM/PAINTED BLACK

Issued For:

CCL06126
CCL06126

3111 BENTON STREET
SANTA CLARA, CA 95051

PREPARED FOR

5001 Executive Parkway
San Ramon, California 94583

Vendor:

COMPLETE
Wireless Consulting, Inc.

AT&T SITE NO: CCL06126
PROJECT NO: -
DRAWN BY: T.T.
CHECKED BY: J. GRAY
APPROVED BY: -

ISSUE STATUS

0	11/15/24	ZD 90%	T.T.
REV	DATE	DESCRIPTION	CAD

Licensee:

PRELIMINARY:
NOT FOR
CONSTRUCTION

KEVIN R. SORENSEN
S4469


IT IS A VIOLATION OF LAW FOR ANY PERSON,
UNLESS THEY ARE ACTING UNDER THE
DIRECTION OF A LICENSED PROFESSIONAL
ENGINEER, TO ALTER THIS DOCUMENT.

ENGINEER:


3843 Taylor Road, Suite A, Lodi, CA 95650
Contact: Kevin Sorensen Phone: 916-660-1930
E-Mail: kevin@streamlineeng.com Fax: 916-660-1941
THESE PLANS AND SPECIFICATIONS ARE INSTRUMENTS OF SERVICE, AND SHALL REMAIN THE PROPERTY OF STREAMLINE ENGINEERING AND DESIGN, INC. ANY REUSE, REPRODUCTION, OR ALTERATION OF THESE PLANS AND SPECIFICATIONS WITHOUT THE WRITTEN CONSENT OF STREAMLINE ENGINEERING AND DESIGN, INC. IS STRICTLY PROHIBITED. ENGINEER: Copyright 2024 BY STREAMLINE ENGINEERING AND DESIGN, INC. ALL RIGHTS RESERVED.

SHEET TITLE:
ENLARGED SITE
PLAN

SHEET NUMBER:
A-1.3

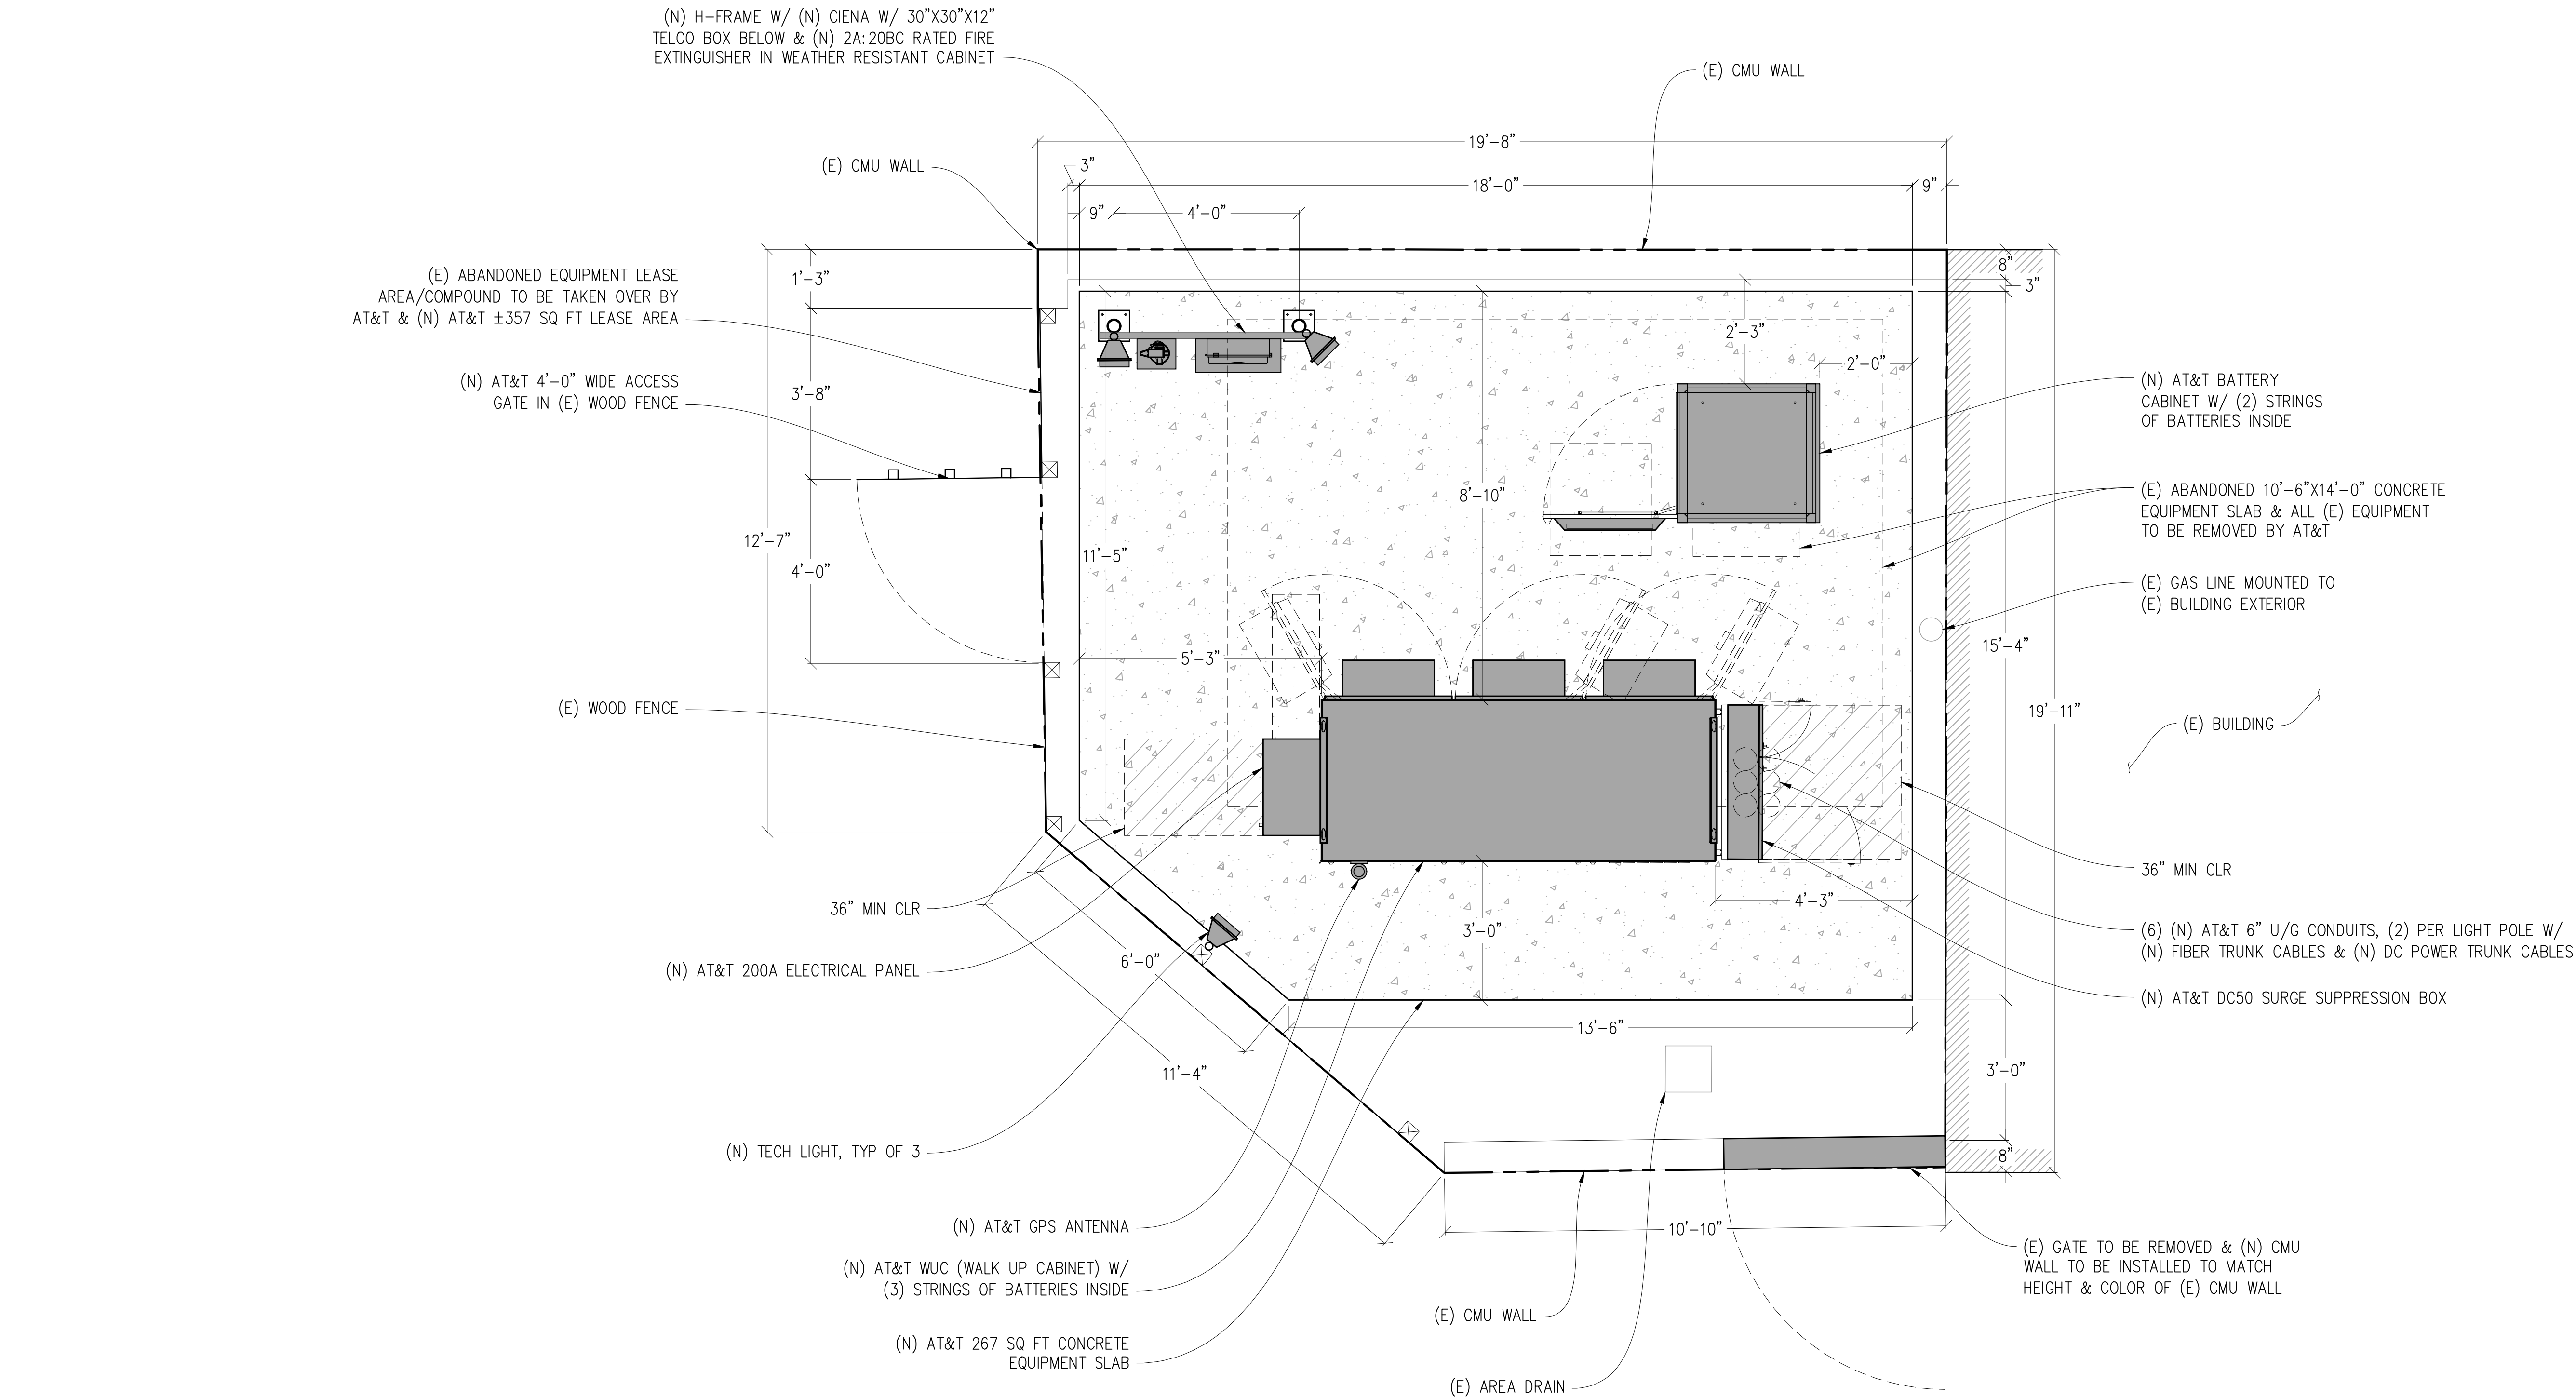

- NOTES:
- ALL (E) ABANDONED U/G CONDUITS UNDER LEASE AREA TO BE REMOVED BY AT&T. LOCATE, REUSE & REROUTE (E) U/G CONDUITS FOR POWER & FIBER FROM OUTSIDE LEASE AREA TO INSIDE LEASE AREA.
 - LOCATE & PROTECT (E) U/G GAS LINE THROUGH LEASE AREA.

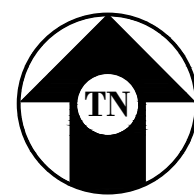

EQUIPMENT PLAN

1/2"=1'-0"



Issued For:

CCL06126
CCL06126

3111 BENTON STREET
SANTA CLARA, CA 95051

PREPARED FOR



5001 Executive Parkway
San Ramon, California 94583

Vendor:



AT&T SITE NO: CCL06126

PROJECT NO: -

DRAWN BY: T.T.

CHECKED BY: J. GRAY

APPROVED BY: -

ISSUE STATUS

REV	DATE	DESCRIPTION	CAD
0	11/15/24	ZD 90%	T.T.

Licensee:

PRELIMINARY:
NOT FOR
CONSTRUCTION

KEVIN R. SORENSEN
S4469

IT IS A VIOLATION OF LAW FOR ANY PERSON,
UNLESS THEY ARE ACTING UNDER THE
DIRECTION OF A LICENSED PROFESSIONAL
ENGINEER, TO ALTER THIS DOCUMENT.

ENGINEER:




SHEET TITLE:

EQUIPMENT
PLAN

SHEET NUMBER:


A-1.4

NOTE:
ALL (N) LIGHT POLES, LIGHT EXTENSION ARMS, LIGHT FIXTURES & (N) AT&T ANTENNAS, ANTENNA MOUNTS, ANTENNA EQUIPMENT & EXPOSED CABLES TO BE COVERED IN 3M FILM/PAINTED BLACK

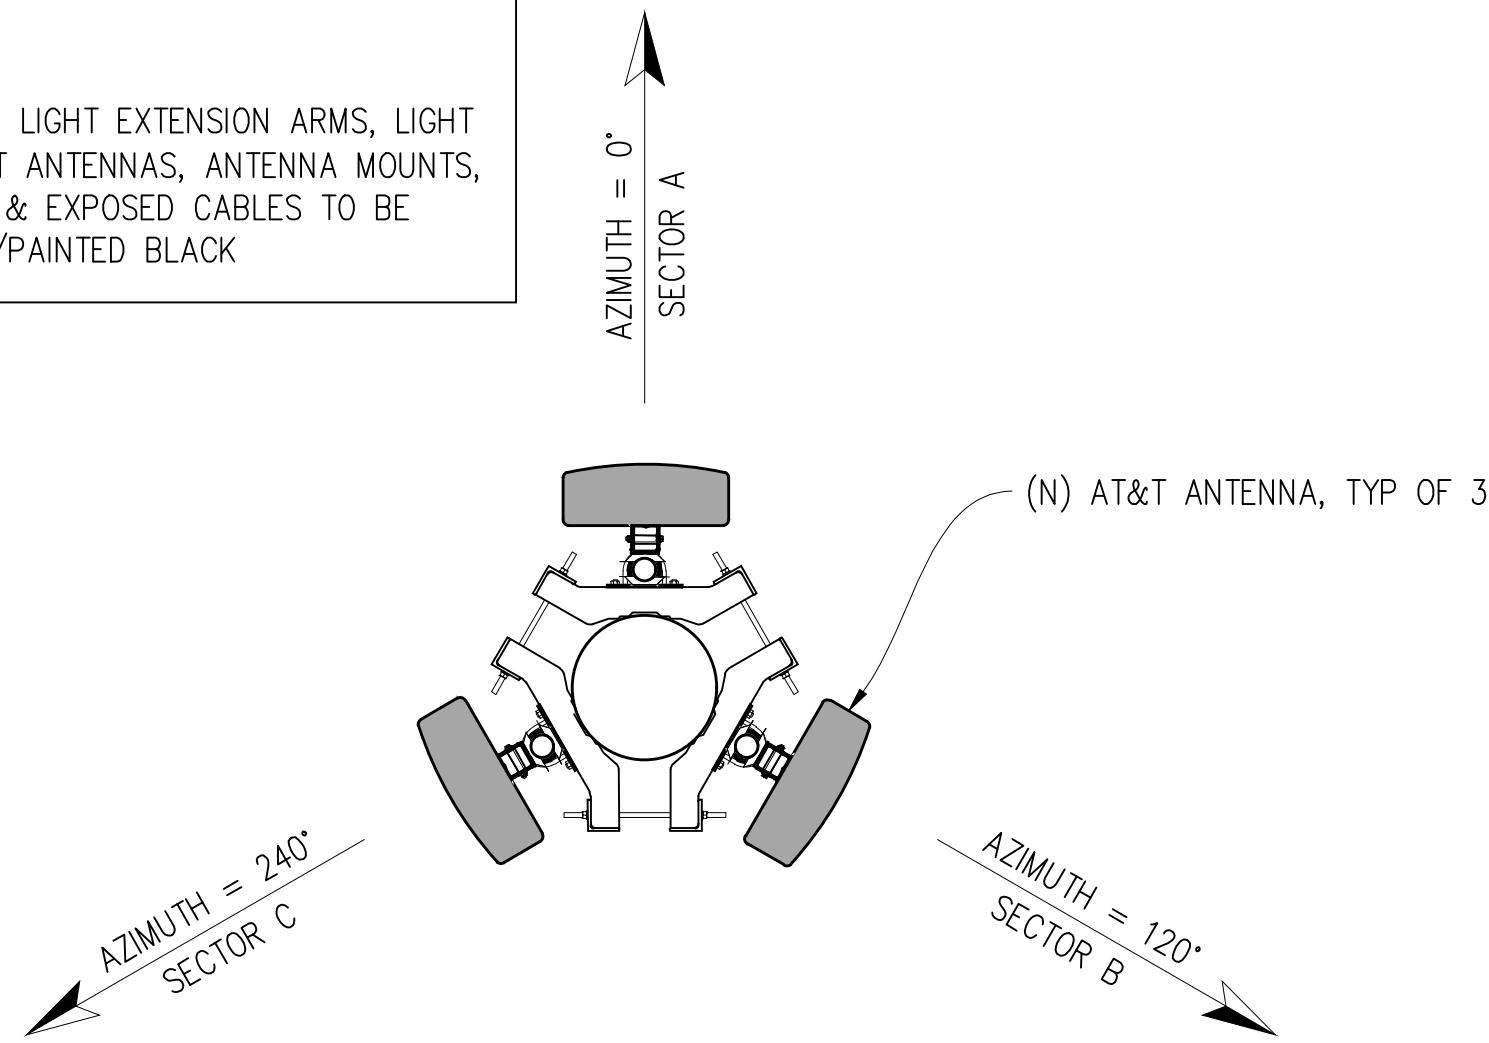


LIGHT POLE #1 ANTENNA PLAN

1/2"=1'-0"

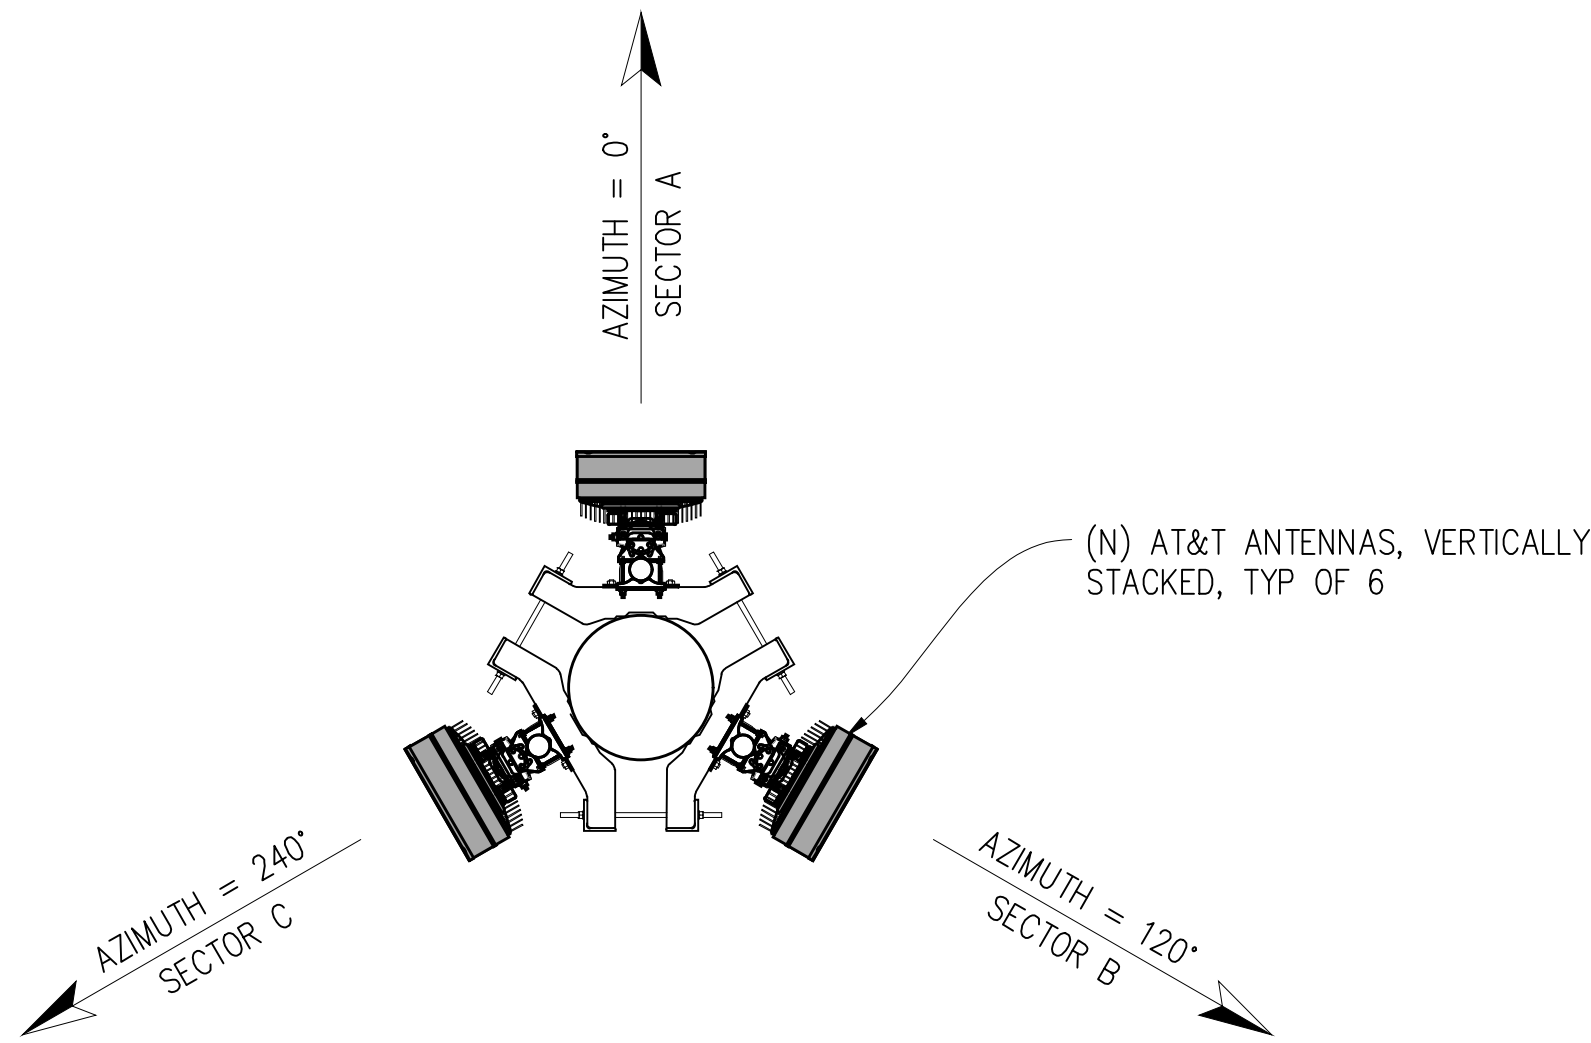


LIGHT POLE #2 ANTENNA PLAN

1/2"=1'-0"

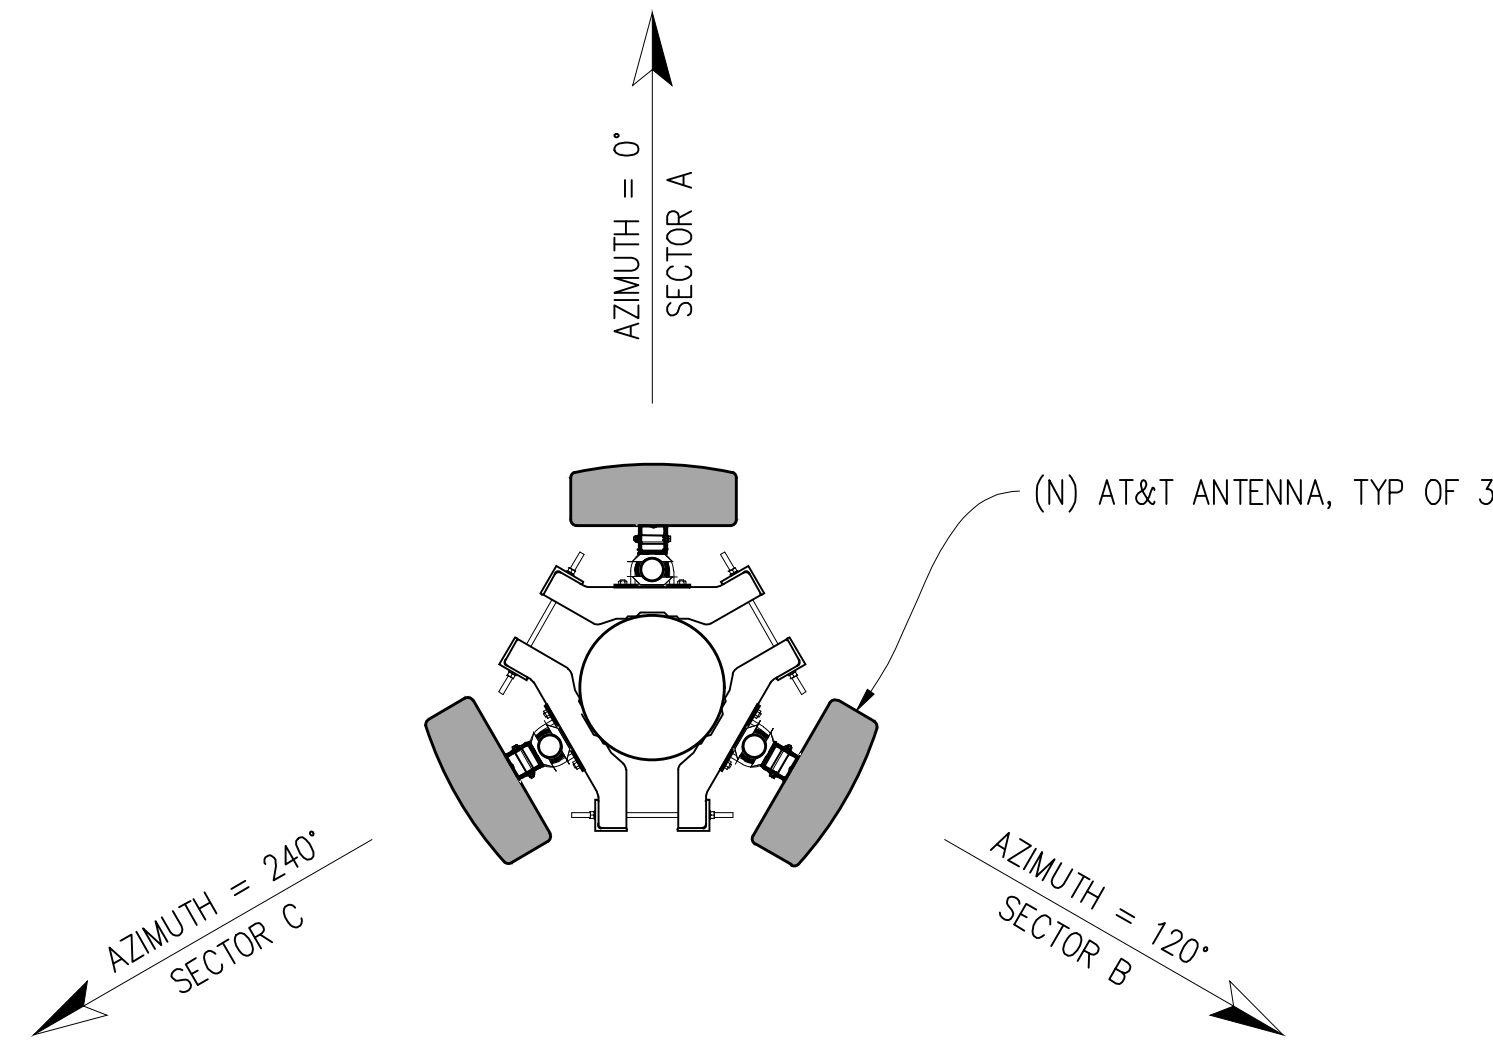


LIGHT POLE #3 ANTENNA PLAN

1/2"=1'-0"

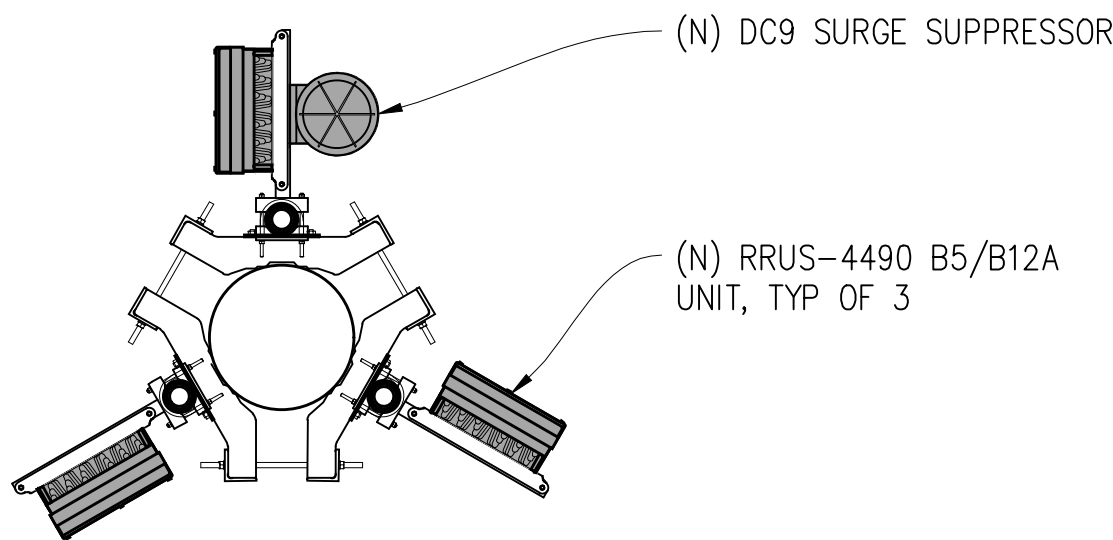


LIGHT POLE #1 RRU PLAN

1/2"=1'-0"

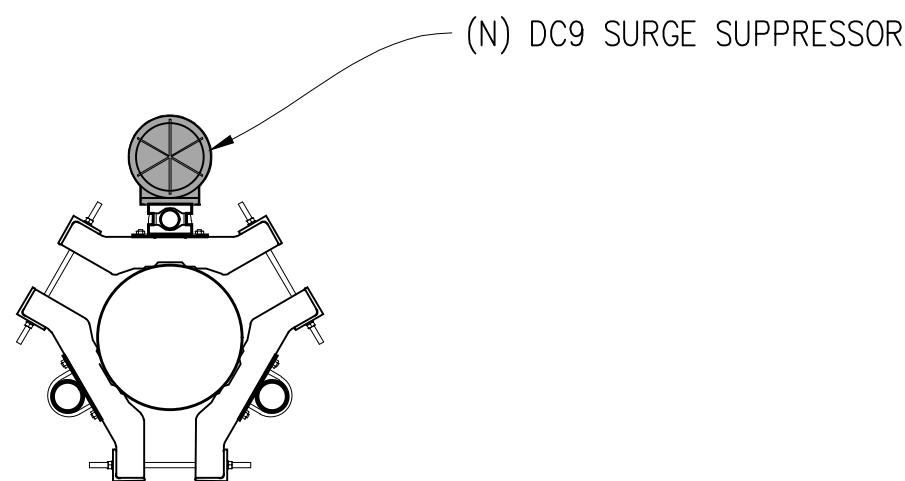


LIGHT POLE #2 RRU PLAN

1/2"=1'-0"

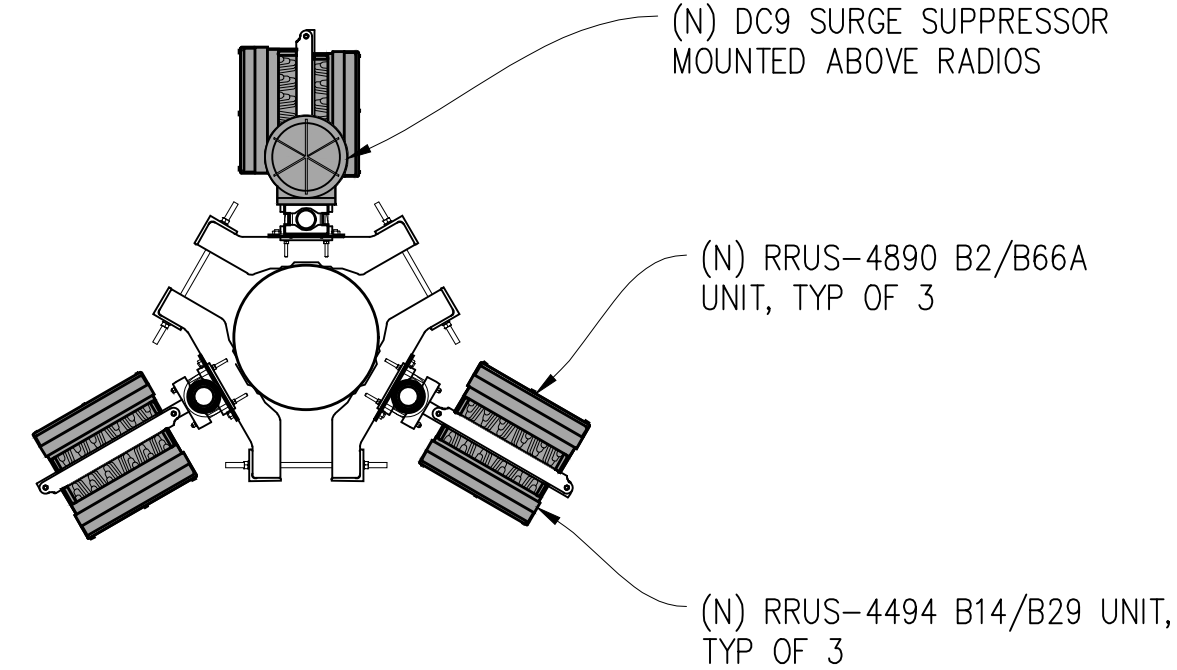


LIGHT POLE #3 RRU PLAN

1/2"=1'-0"

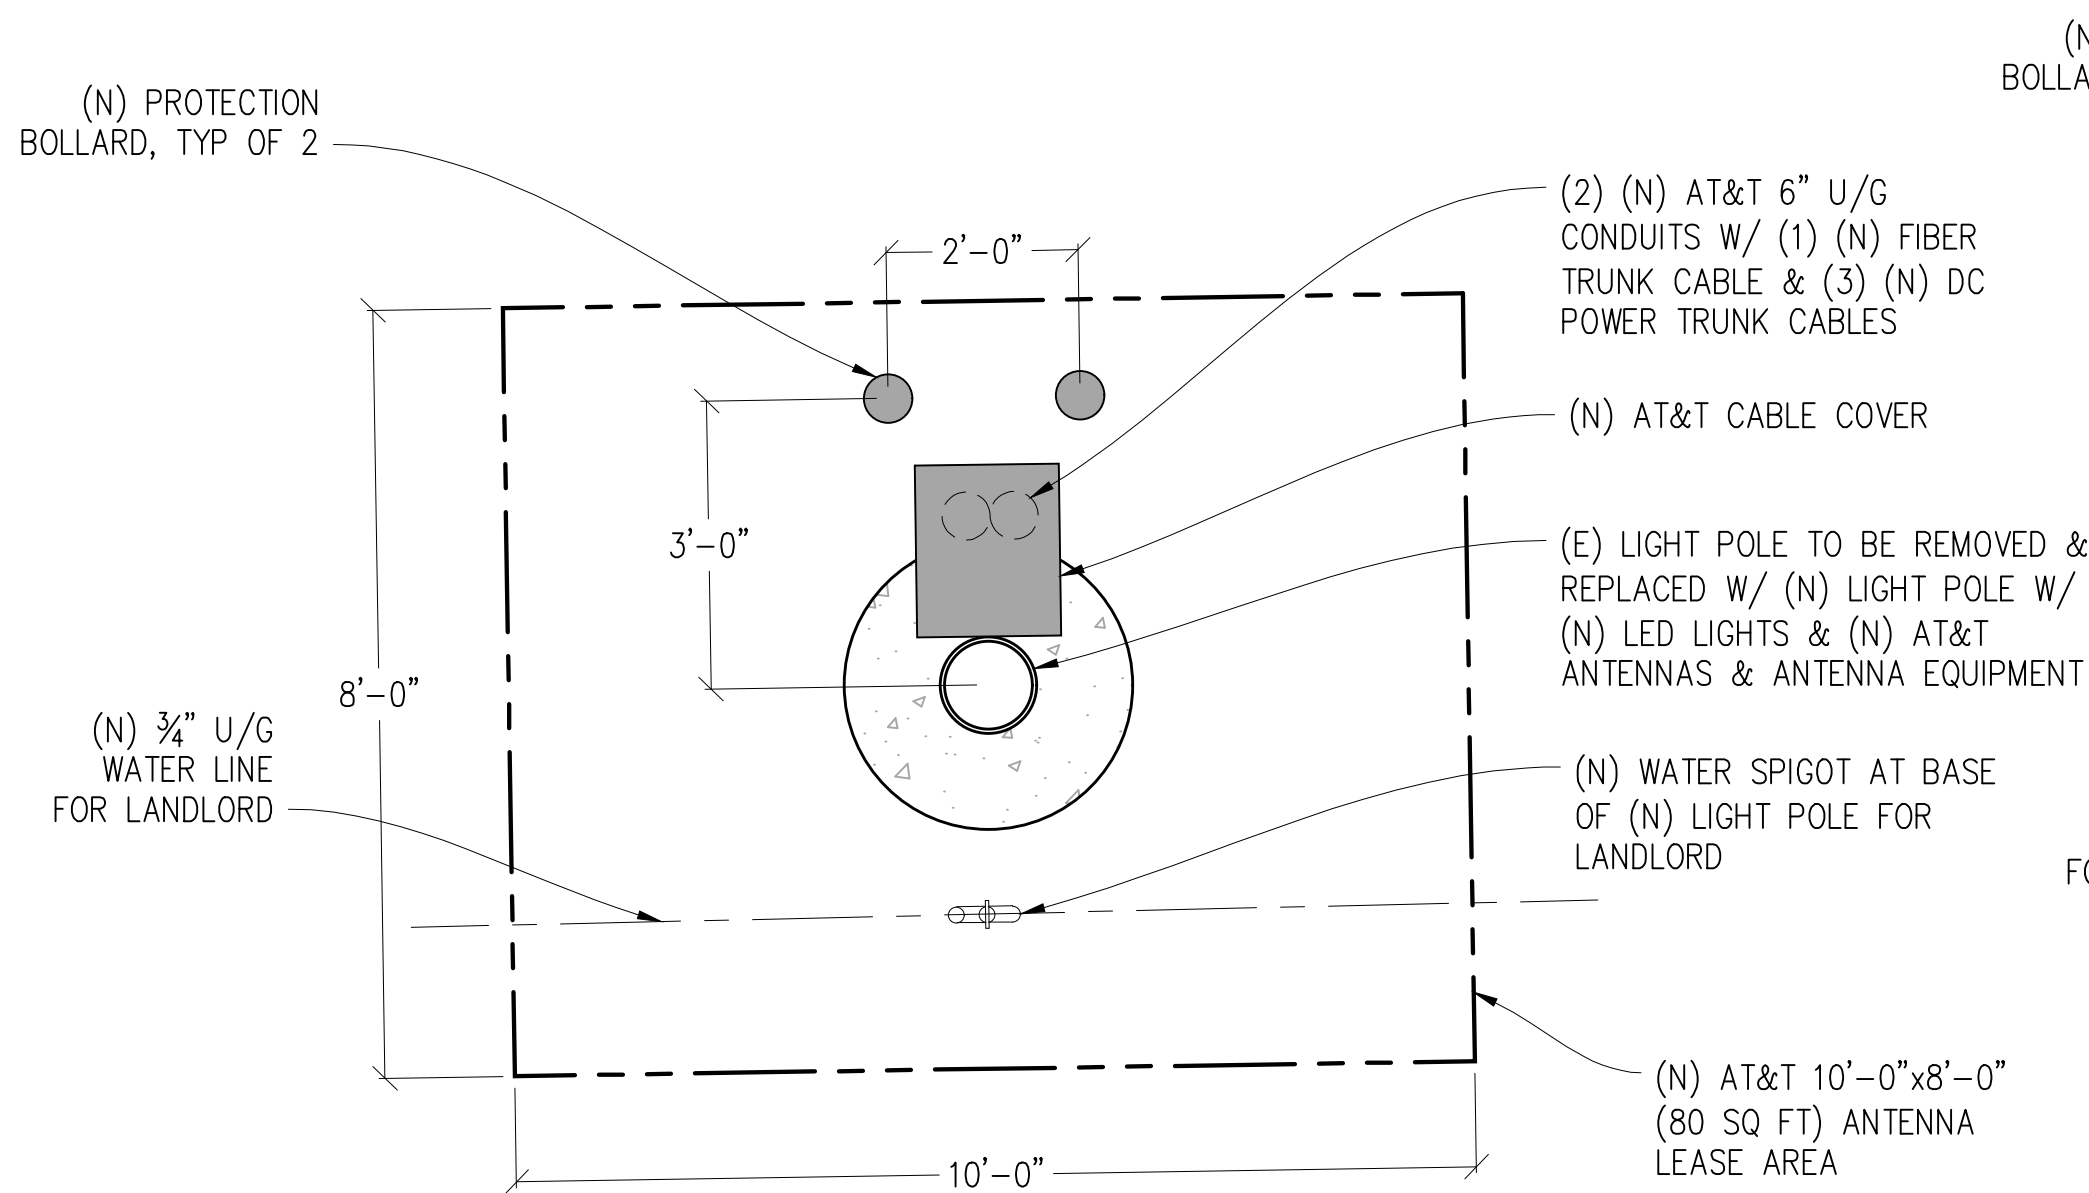


LIGHT POLE #1 BASE PLAN

1/2"=1'-0"

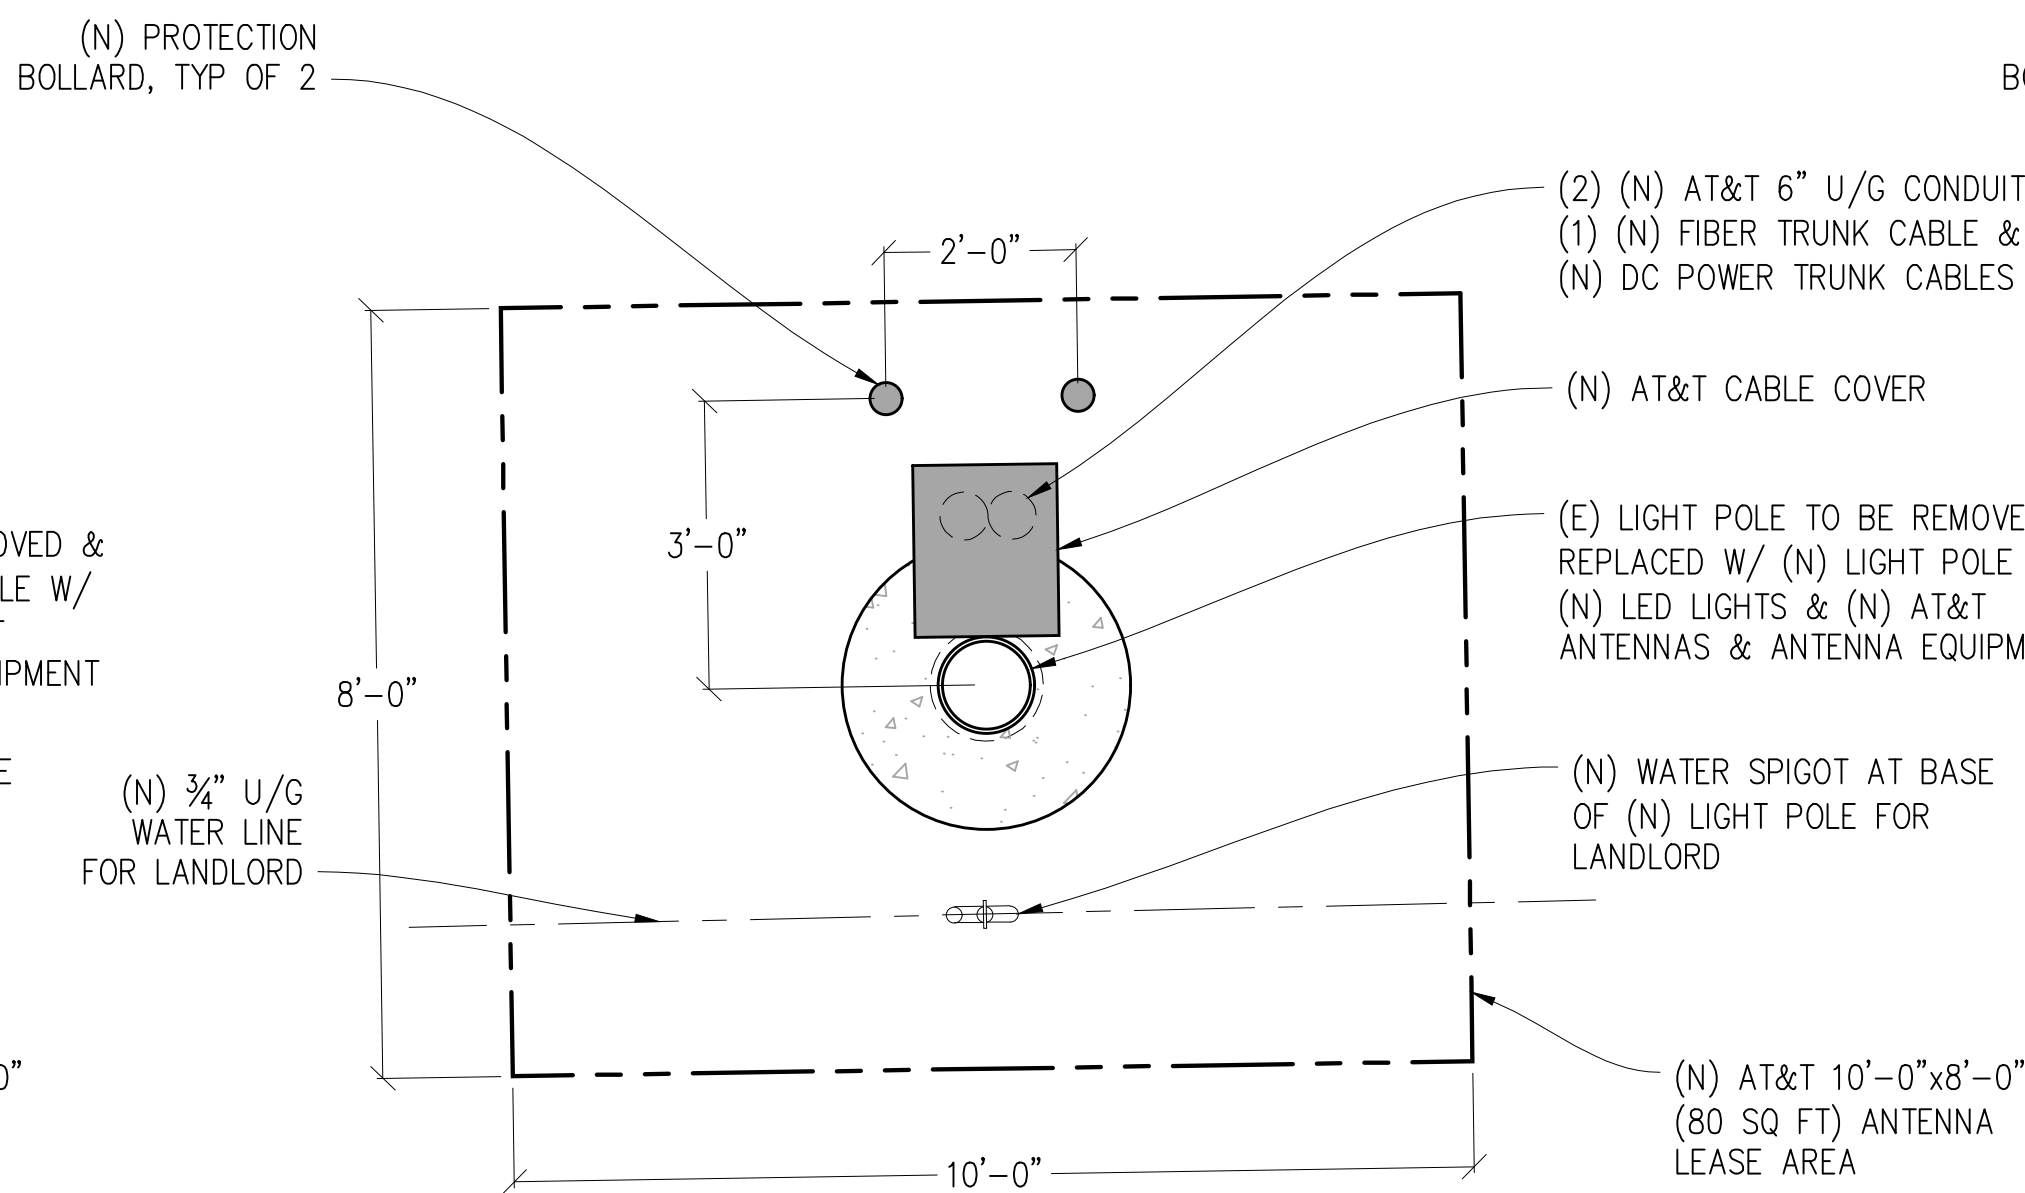

LIGHT POLE #2 BASE PLAN

1/2"=1'-0"

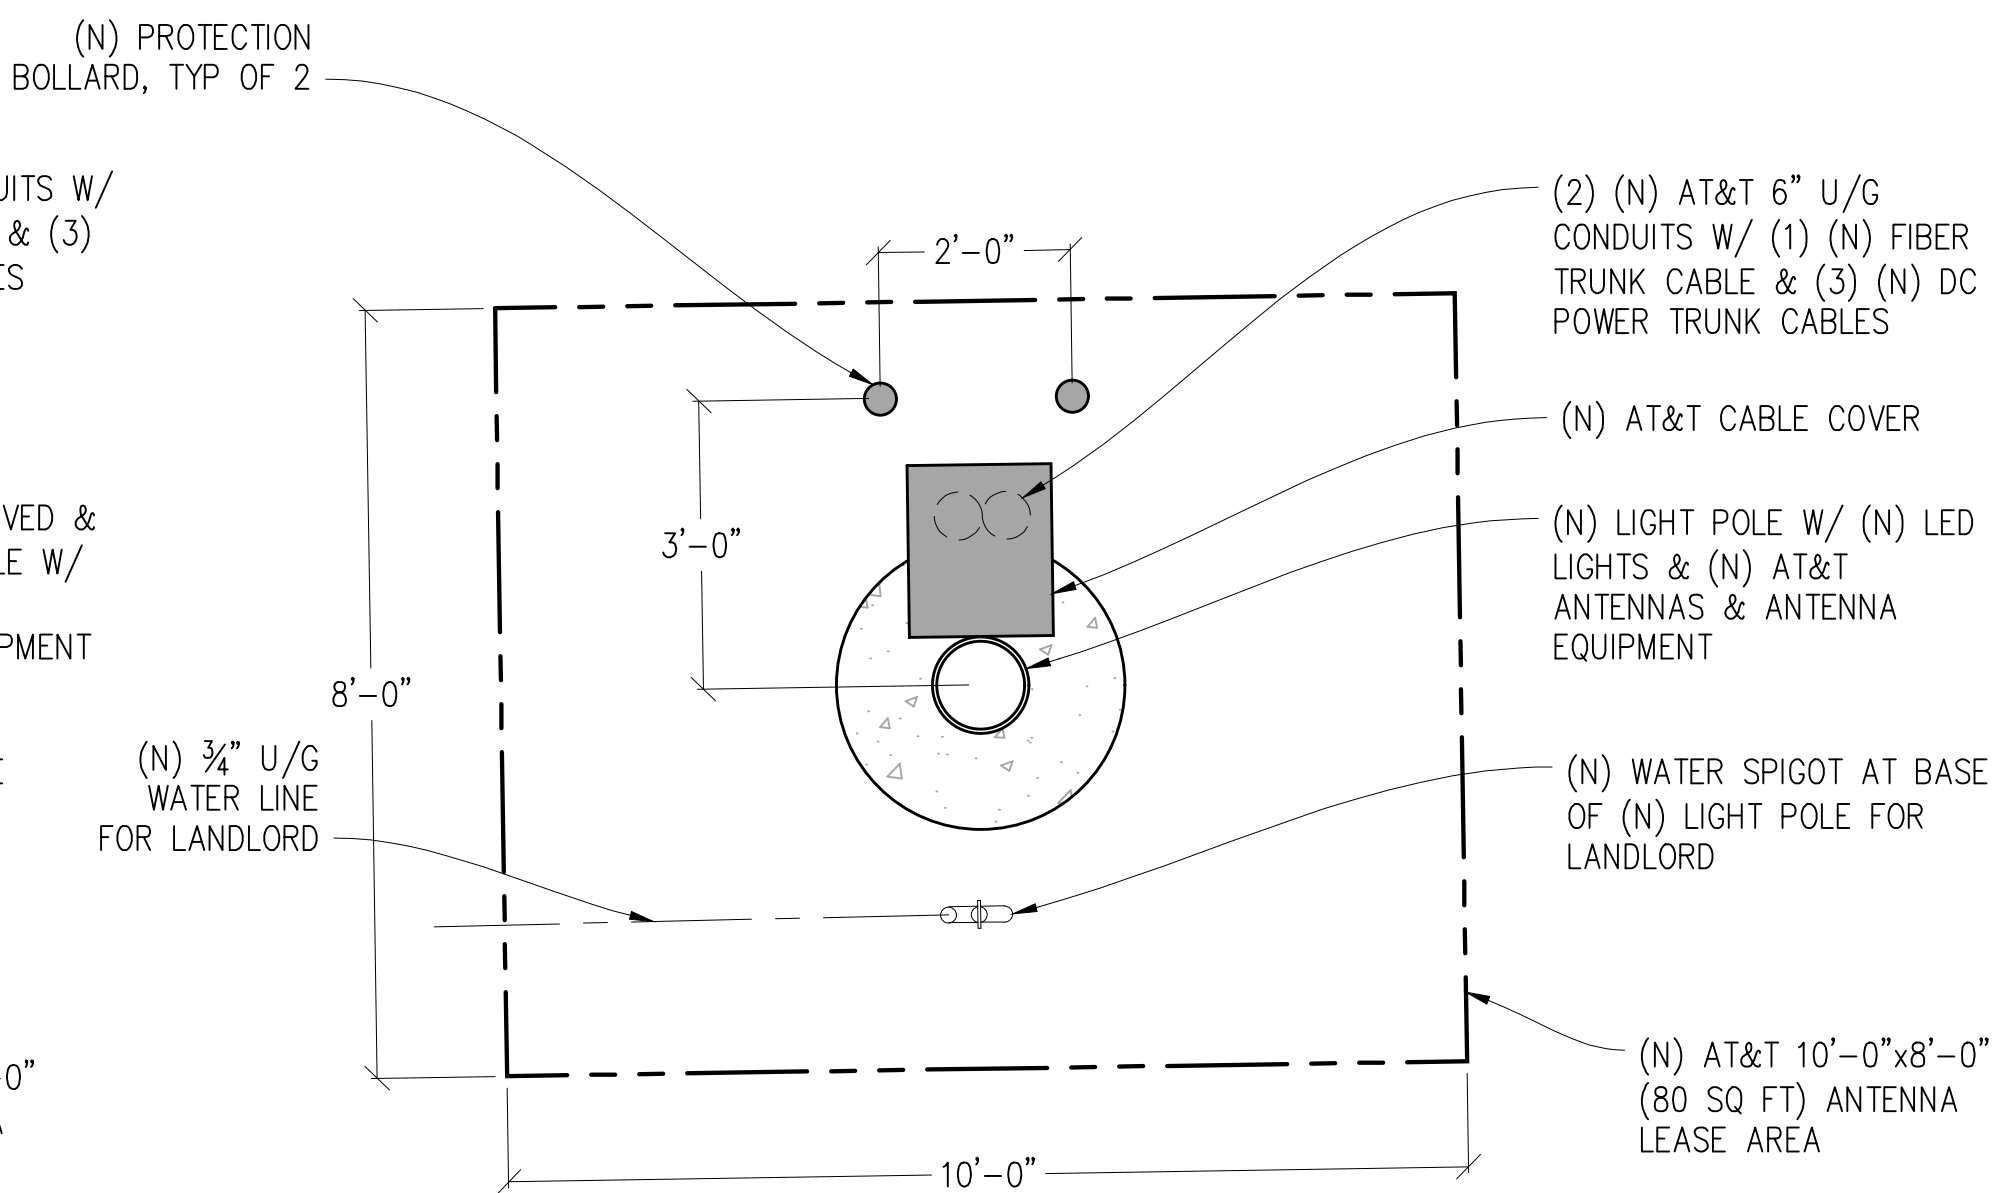

LIGHT POLE #3 BASE PLAN

1/2"=1'-0"



Issued For:

CCL06126
CCL06126

3111 BENTON STREET
SANTA CLARA, CA 95051

PREPARED FOR



5001 Executive Parkway
San Ramon, California 94583

Vendor:



AT&T SITE NO: CCL06126

PROJECT NO: -

DRAWN BY: T.T.

CHECKED BY: J. GRAY

APPROVED BY: -

ISSUE STATUS

REV	DATE	DESCRIPTION	CAD
0	11/15/24	ZD 90%	T.T.

Licensee:

PRELIMINARY:
NOT FOR
CONSTRUCTION

KEVIN R. SORENSEN
S4469

IT IS A VIOLATION OF LAW FOR ANY PERSON,
UNLESS THEY ARE ACTING UNDER THE
DIRECTION OF A LICENSED PROFESSIONAL
ENGINEER, TO ALTER THIS DOCUMENT.

ENGINEER:



SHEET TITLE:

ANTENNA PLANS

SHEET NUMBER:

A-2.1

(N) RF SCHEDULE (PRELIMINARY & SUBJECT TO CHANGE)											
SECTOR		ANTENNA MODEL NO.	AZIMUTH	CENTERLINE	RRU NO'S & MODEL #	# OF DC POWER CABLES	# OF FIBER CABLES	LENGTH OF CABLES	SURGE SUPPRESSOR	NO. OF DIPLEXERS	NO. OF COMBINERS
ALPHA	A1	CCI OPA65R-BU6D	0°	±39'-6"	(1) RRUS-4490 B5/B12A	3	1	±400'	(1) DC9	-	-
	A2A	ERICSSON AIR6419 B77G	0°	±41'-3"	INTEGRATED	3	1	±490'	(1) DC9	-	-
	A2B	ERICSSON AIR6449 B77D	0°	±37'-9"	INTEGRATED	SHARED	SHARED	SHARED	SHARED	-	-
	A3	CCI TPA65R-BU6DV2	0°	±39'-6"	(1) RRUS-4494 B14/B29, (1) RRUS-4890 B2/B66A	3	1	±585'	(1) DC9	-	-
BETA	B1	CCI OPA65R-BU6D	120°	±39'-6"	(1) RRUS-4490 B5/B12A	SHARED	SHARED	SHARED	SHARED	-	-
	B2A	ERICSSON AIR6419 B77G	120°	±41'-3"	INTEGRATED	SHARED	SHARED	SHARED	SHARED	-	-
	B2B	ERICSSON AIR6449 B77D	120°	±37'-9"	INTEGRATED	SHARED	SHARED	SHARED	SHARED	-	-
	B3	CCI TPA65R-BU6DV2	120°	±39'-6"	(1) RRUS-4494 B14/B29, (1) RRUS-4890 B2/B66A	SHARED	SHARED	SHARED	SHARED	-	-
GAMMA	C1	CCI OPA65R-BU6D	240°	±39'-6"	(1) RRUS-4490 B5/B12A	SHARED	SHARED	SHARED	SHARED	-	-
	C2A	ERICSSON AIR6419 B77G	240°	±41'-3"	INTEGRATED	SHARED	SHARED	SHARED	SHARED	-	-
	C2B	ERICSSON AIR6449 B77D	240°	±37'-9"	INTEGRATED	SHARED	SHARED	SHARED	SHARED	-	-
	C3	CCI TPA65R-BU6DV2	240°	±39'-6"	(1) RRUS-4494 B14/B29, (1) RRUS-4890 B2/B66A	SHARED	SHARED	SHARED	SHARED	-	-

RFDS DATE	11/08/24	NOTE: 1. ANTENNA POSITIONS ARE LEFT TO RIGHT FROM BACK OF ANTENNA. 2. EQUIPMENT IS PRELIMINARY & SUBJECT TO CHANGE.
-----------	----------	--

Issued For:

CCL06126
CCL06126

3111 BENTON STREET
SANTA CLARA, CA 95051

PREPARED FOR


5001 Executive Parkway
San Ramon, California 94583

Vendor:



AT&T SITE NO: CCL06126
PROJECT NO: -
DRAWN BY: T.T.
CHECKED BY: J. GRAY
APPROVED BY: -

ISSUE STATUS			
0	11/15/24	ZD 90%	T.T.
REV	DATE	DESCRIPTION	CAD

Licensee:

PRELIMINARY:
NOT FOR
CONSTRUCTION

KEVIN R. SORENSEN
\$4469

IT IS A VIOLATION OF LAW FOR ANY PERSON,
UNLESS THEY ARE ACTING UNDER THE
DIRECTION OF A LICENSED PROFESSIONAL
ENGINEER, TO ALTER THIS DOCUMENT.

ENGINEER:


3843 Taylor Road, Suite A, Lodi, CA 95660
Contact: Kevin Sorensen Phone: 916-660-1930
E-Mail: kevin@streamlineeng.com Fax: 916-660-1941
THESE PLANS AND SPECIFICATIONS ARE INSTRUMENTS OF SERVICE, AND SHALL REMAIN THE PROPERTY OF STREAMLINE ENGINEERING AND DESIGN, INC. ANY REUSE, REPRODUCTION, OR ALTERATION OF THESE PLANS AND SPECIFICATIONS WITHOUT THE WRITTEN CONSENT OF STREAMLINE ENGINEERING AND DESIGN, INC. IS STRICTLY PROHIBITED. Copyright 2020, © STREAMLINE ENGINEERING AND DESIGN, INC. ALL RIGHTS RESERVED.

SHEET TITLE:

ANTENNA
SCHEDULE



SHEET NUMBER:

A-2.2

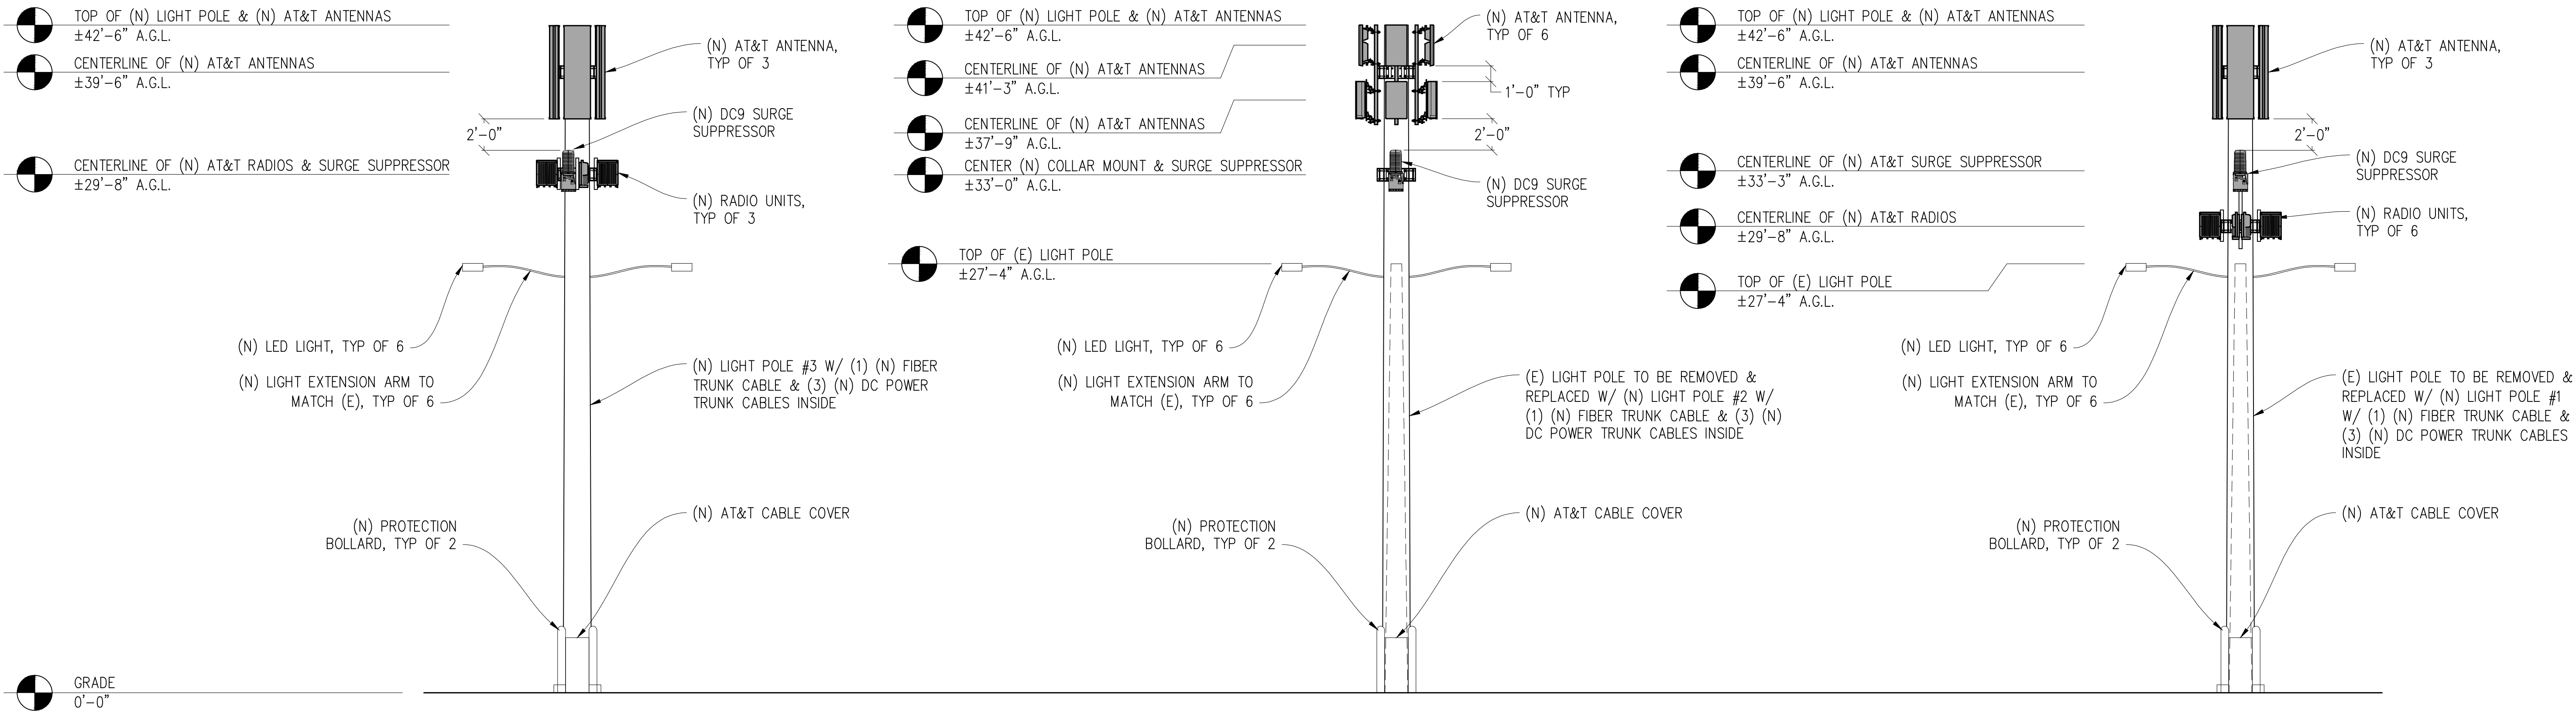


NORTH ELEVATION

 3/16"=1'-0"

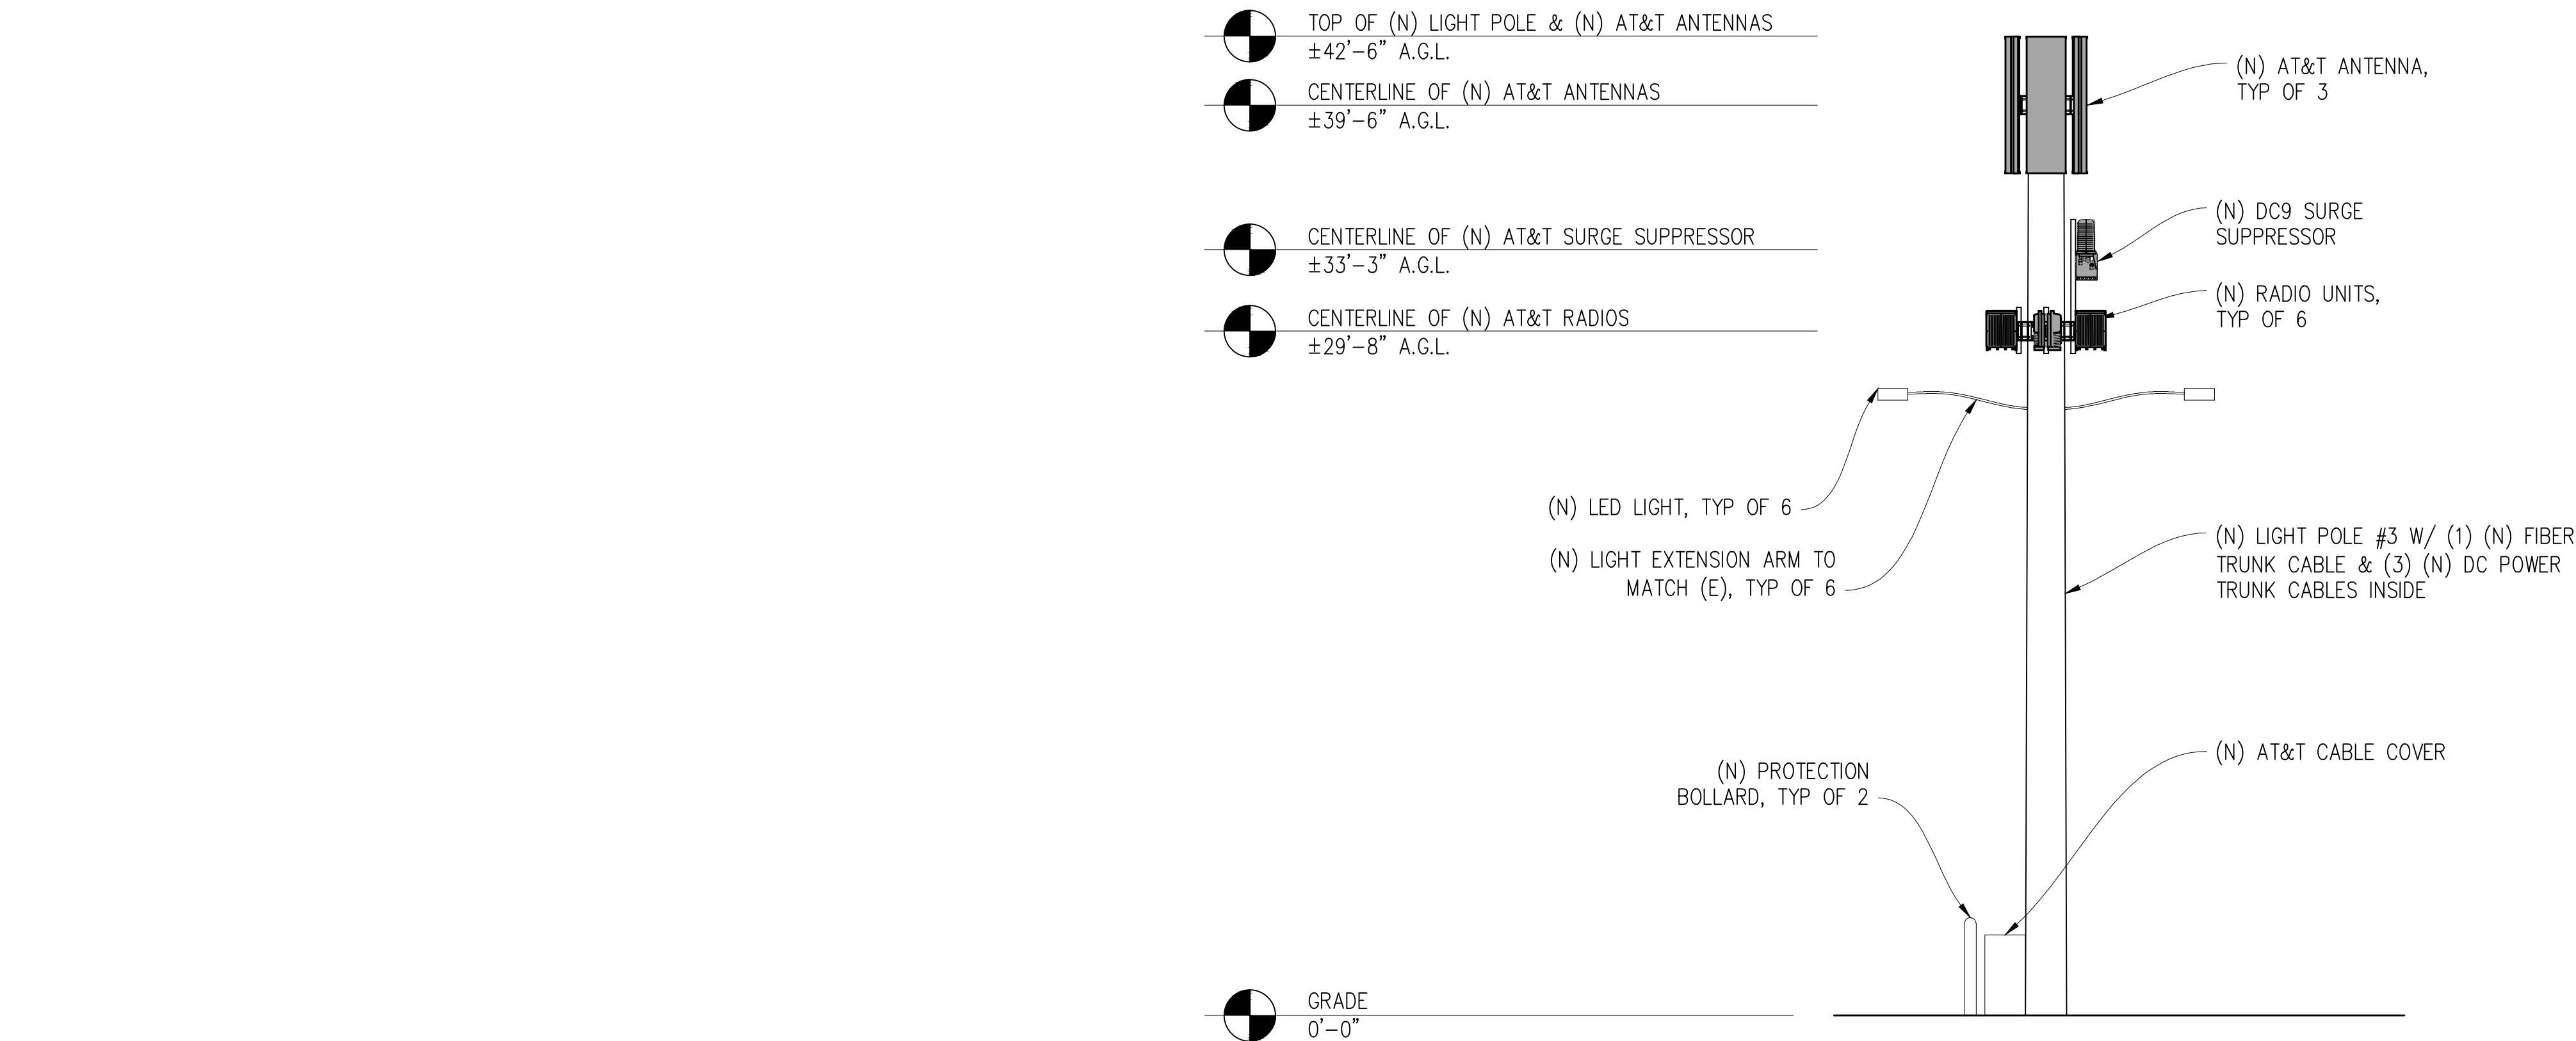

EAST ELEVATION

 3/16"=1'-0"



NOTE: (N) LED LIGHTS TO BE INSTALLED AT SAME HEIGHT AS (E) LIGHTS

NOTE:

ALL (N) LIGHT POLES, LIGHT EXTENSION ARMS, LIGHT FIXTURES & (N) AT&T ANTENNAS, ANTENNA MOUNTS, ANTENNA EQUIPMENT & EXPOSED CABLES TO BE COVERED IN 3M FILM/PAINTED BLACK

Issued For:

CCL06126
CCL06126

3111 BENTON STREET
SANTA CLARA, CA 95051

PREPARED FOR



5001 Executive Parkway
San Ramon, California 94583

Vendor:



AT&T SITE NO: CCL06126

PROJECT NO: -

DRAWN BY: T.T.

CHECKED BY: J. GRAY

APPROVED BY: -

ISSUE STATUS

REV	DATE	DESCRIPTION	CAD
0	11/15/24	ZD 90%	T.T.

Licensee:

PRELIMINARY:
NOT FOR
CONSTRUCTION

KEVIN R. SORENSEN
\$4469

IT IS A VIOLATION OF LAW FOR ANY PERSON, UNLESS THEY ARE ACTING UNDER THE DIRECTION OF A LICENSED PROFESSIONAL ENGINEER, TO ALTER THIS DOCUMENT.

ENGINEER:





SHEET TITLE:

ELEVATIONS

SHEET NUMBER:

A-3.1

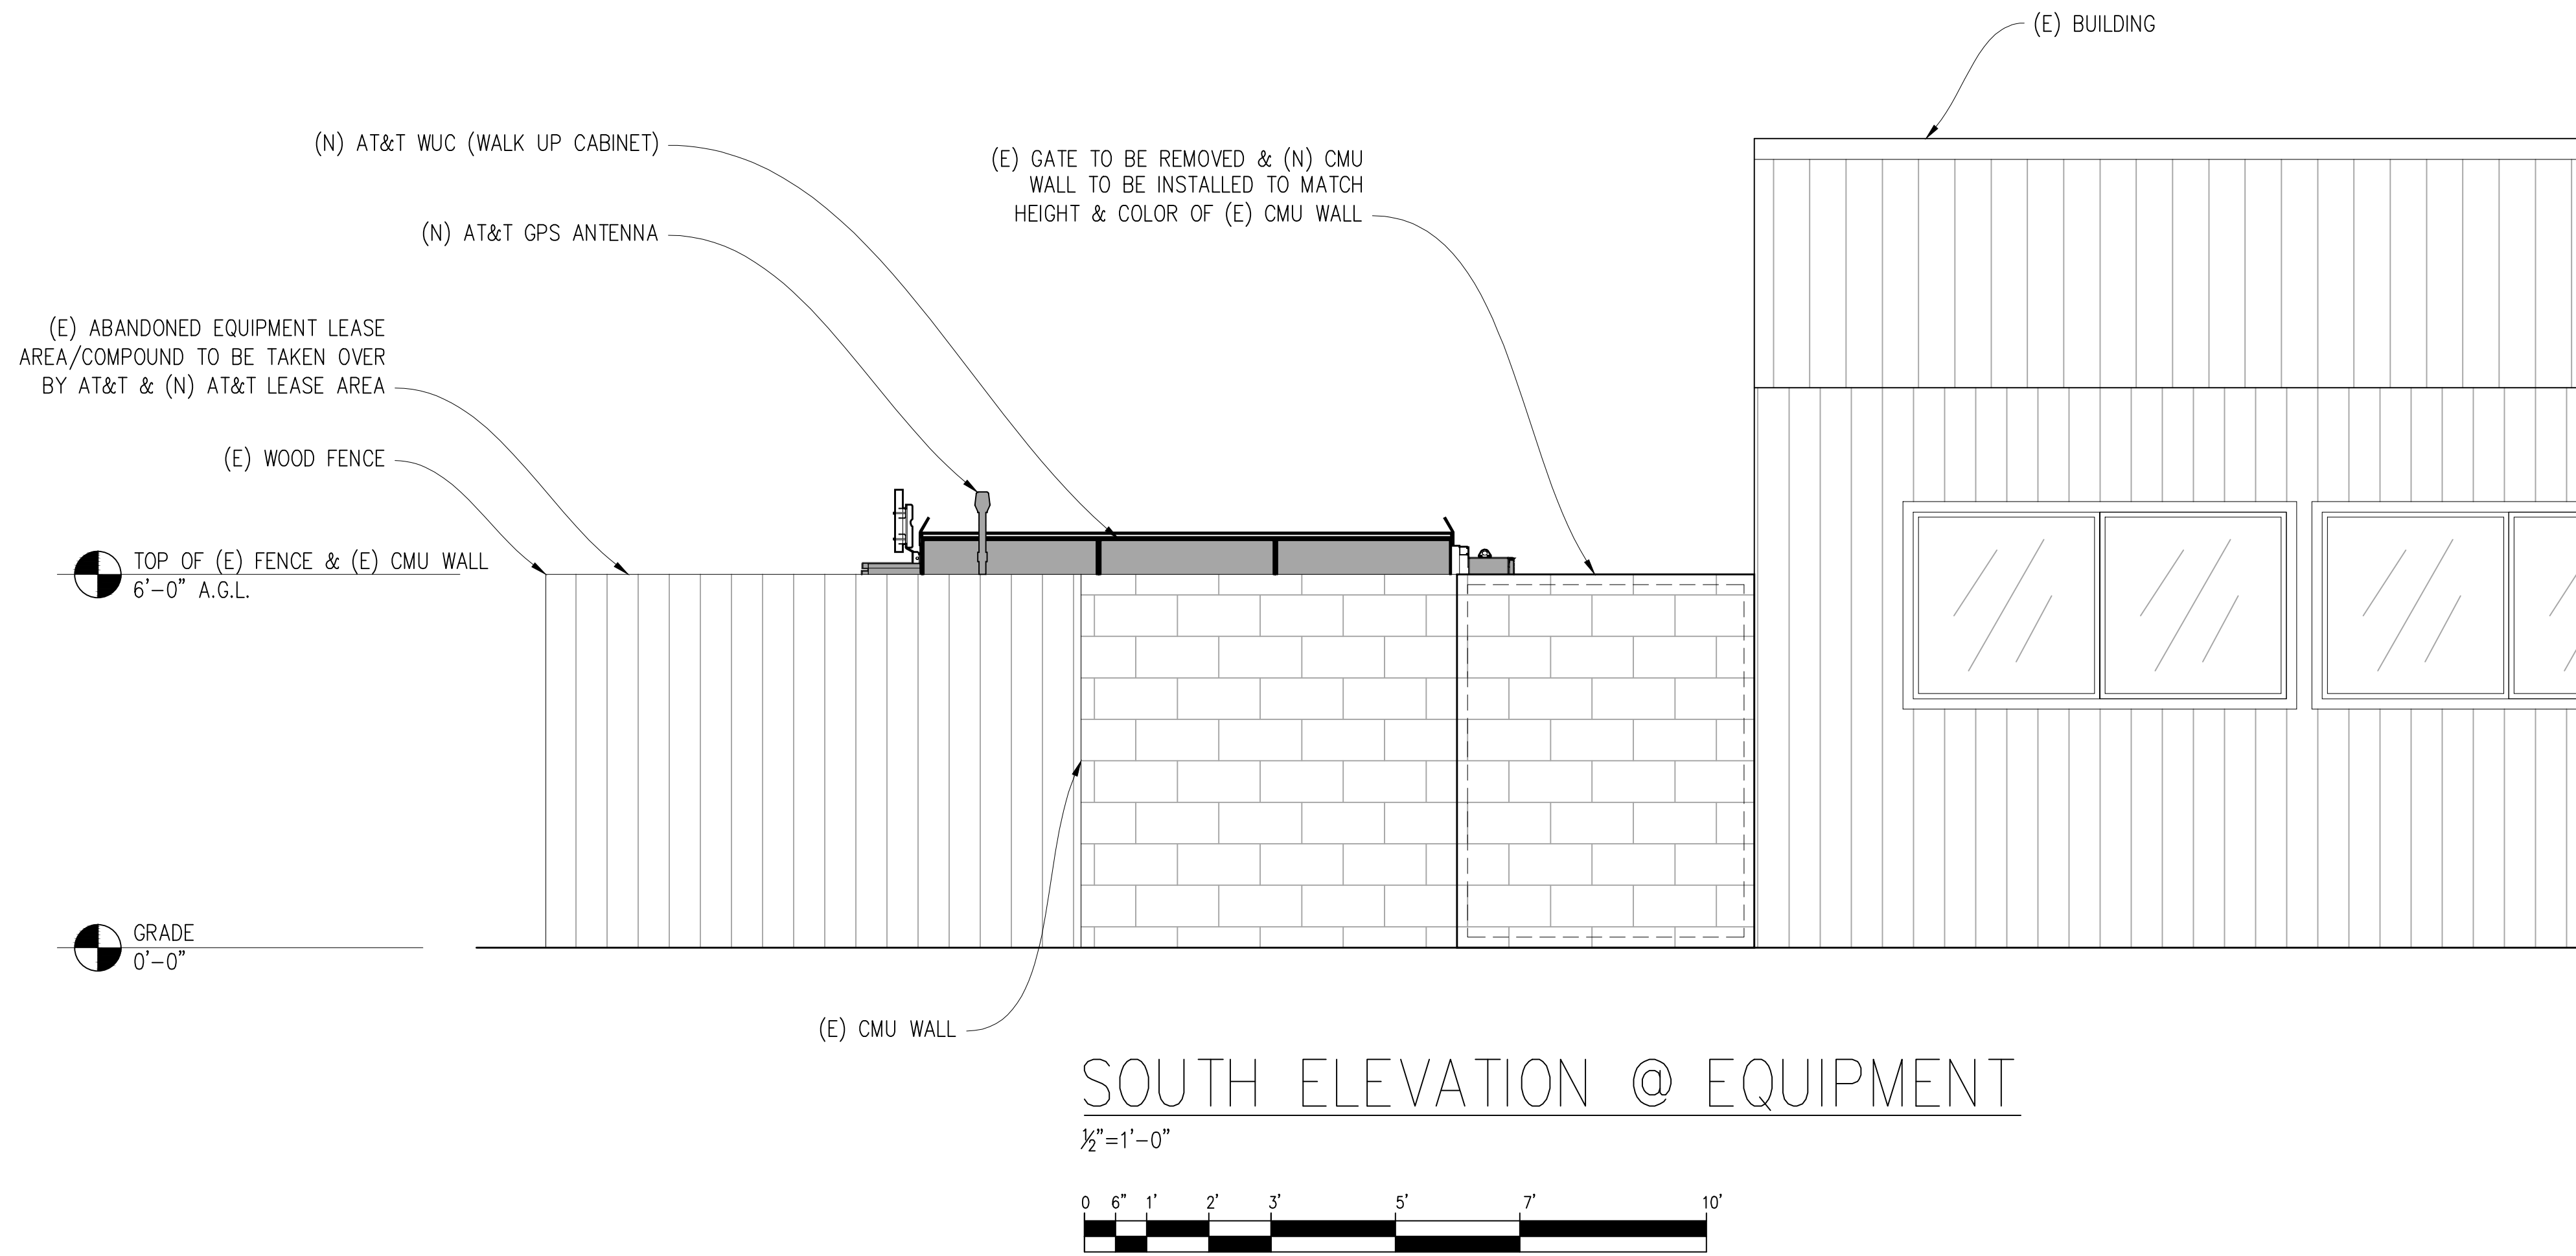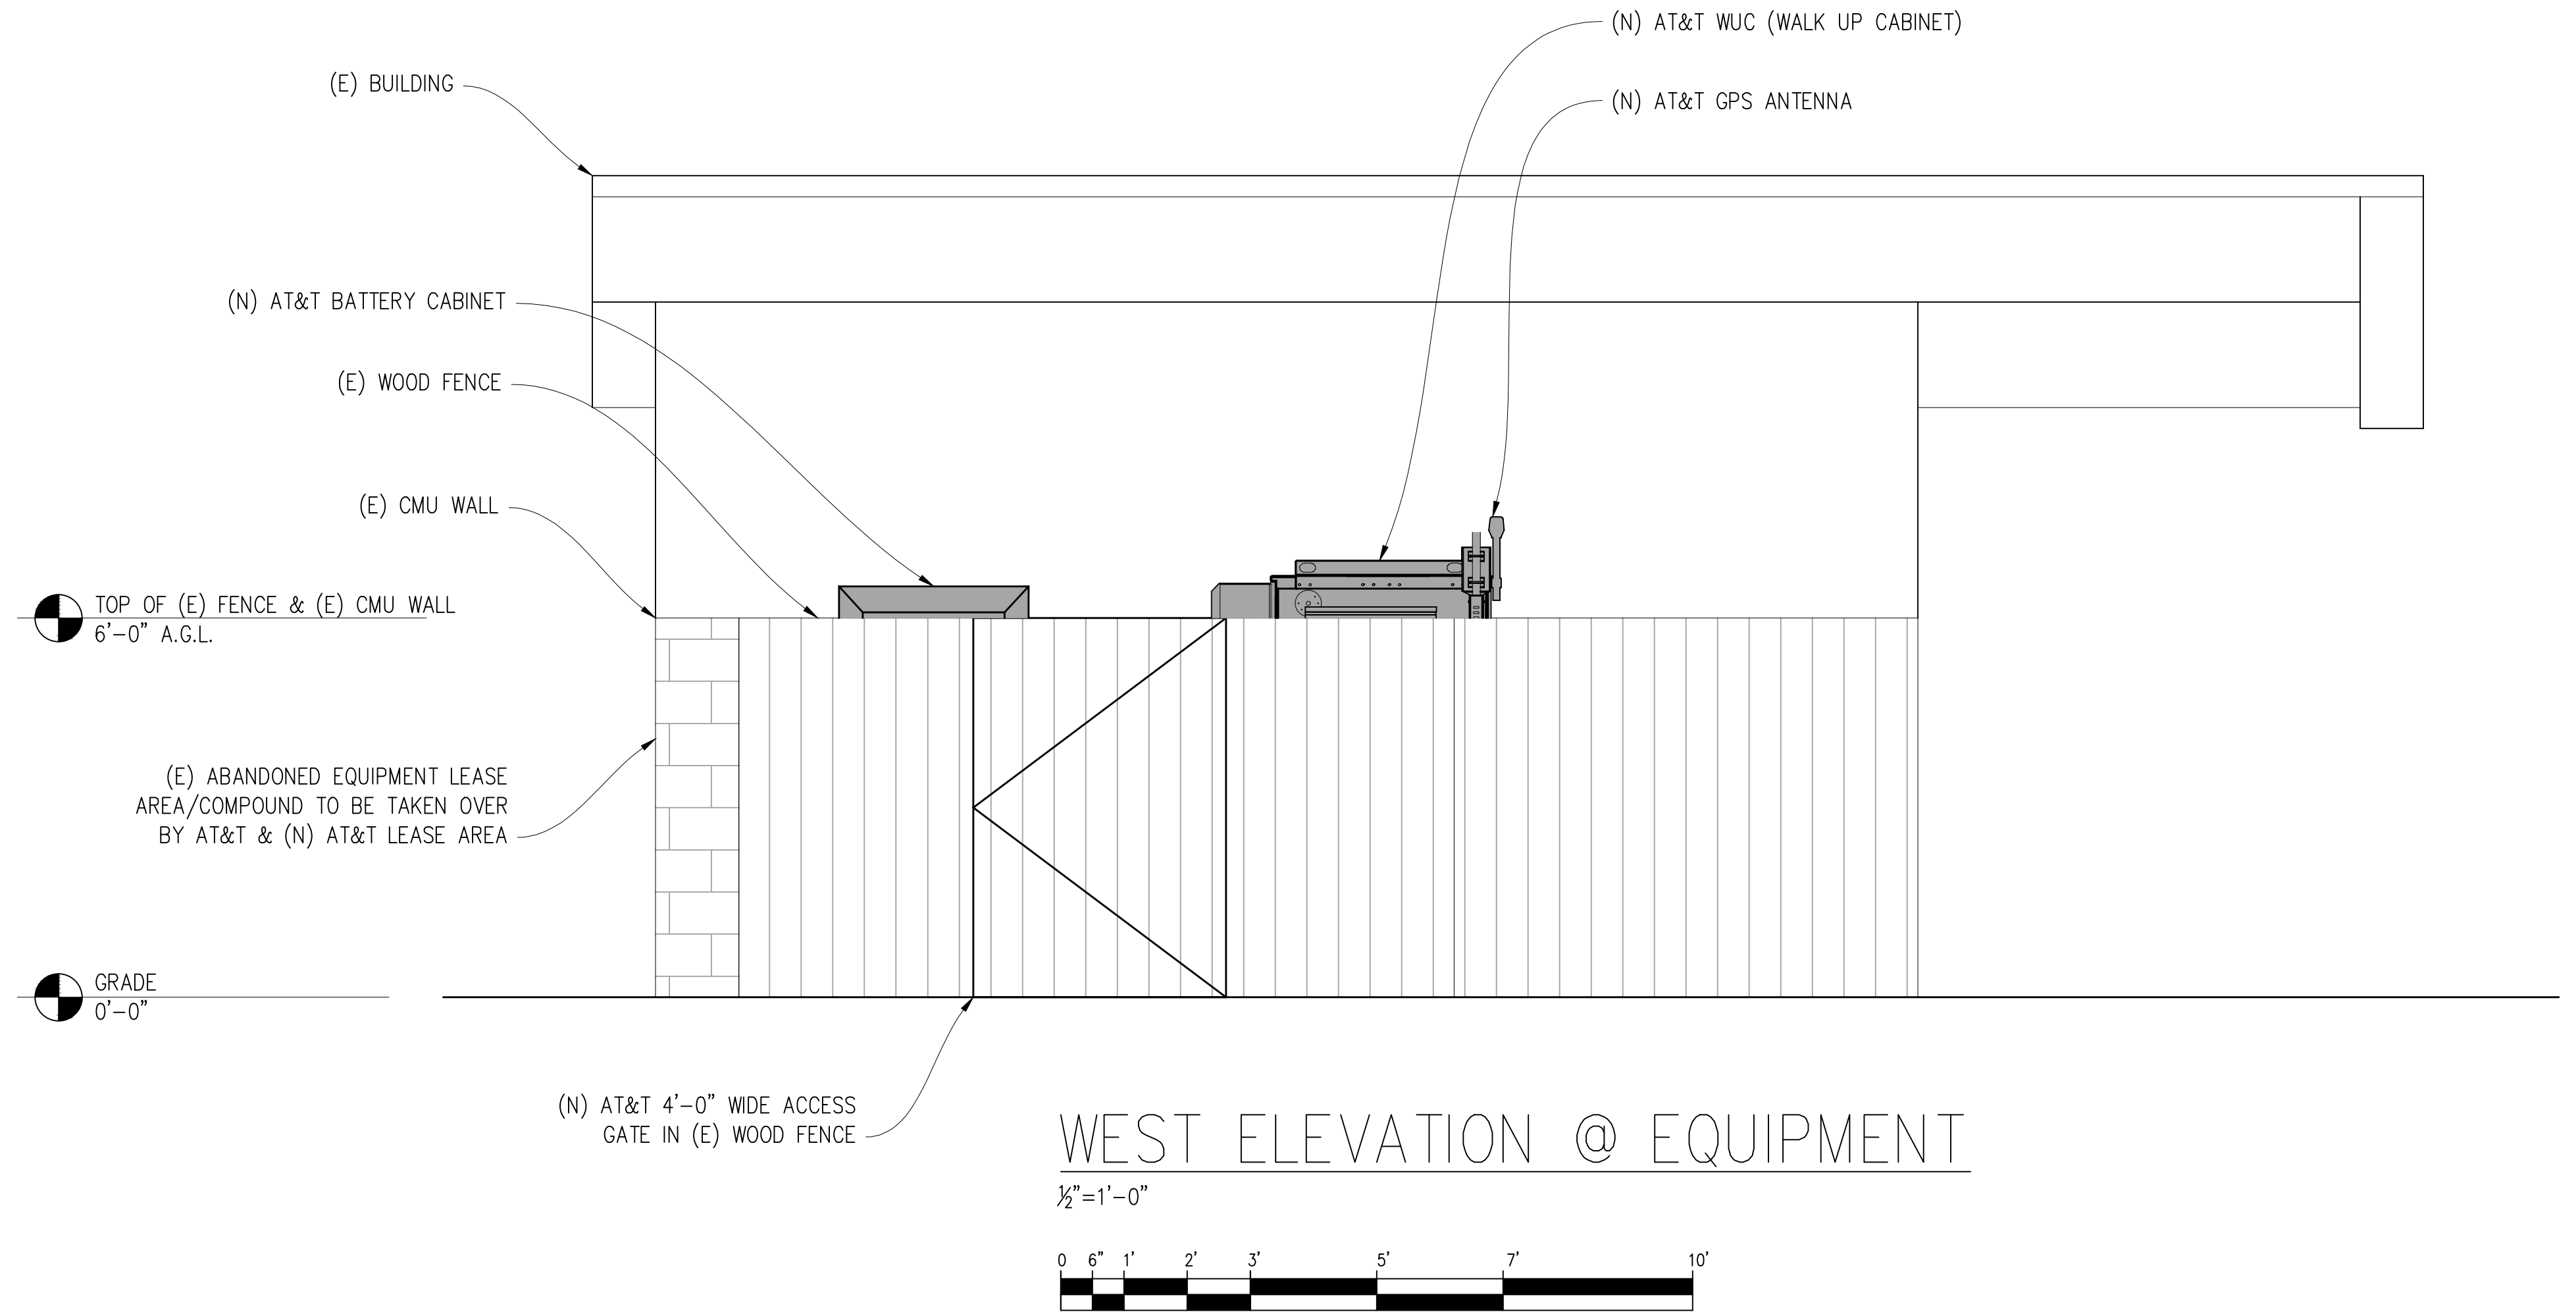

Issued For:

CCL06126
CCL06126

3111 BENTON STREET
SANTA CLARA, CA 95051

PREPARED FOR



5001 Executive Parkway
San Ramon, California 94583

Vendor:



AT&T SITE NO: CCL06126

PROJECT NO: -

DRAWN BY: T.T.

CHECKED BY: J. GRAY

APPROVED BY: -

ISSUE STATUS

REV	DATE	DESCRIPTION	CAD
0	11/15/24	ZD 90%	T.T.

Licensee:

PRELIMINARY:
NOT FOR
CONSTRUCTION

KEVIN R. SORENSEN
S4469

IT IS A VIOLATION OF LAW FOR ANY PERSON,
UNLESS THEY ARE ACTING UNDER THE
DIRECTION OF A LICENSED PROFESSIONAL
ENGINEER, TO ALTER THIS DOCUMENT.

ENGINEER:




SHEET TITLE:


ELEVATIONS

SHEET NUMBER:


A-3.2

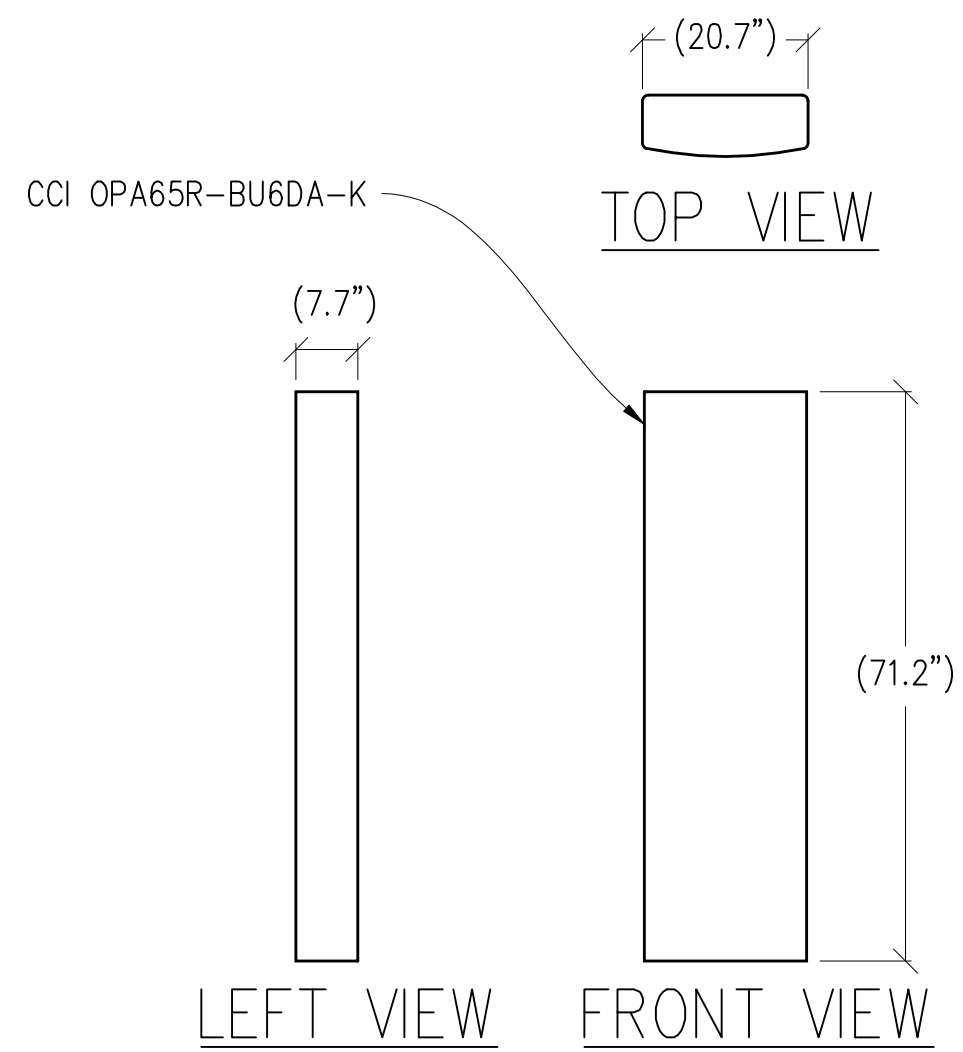


1 ANTENNA DETAIL
1/2"=1'-0" MAX WEIGHT: 75.9 LBS

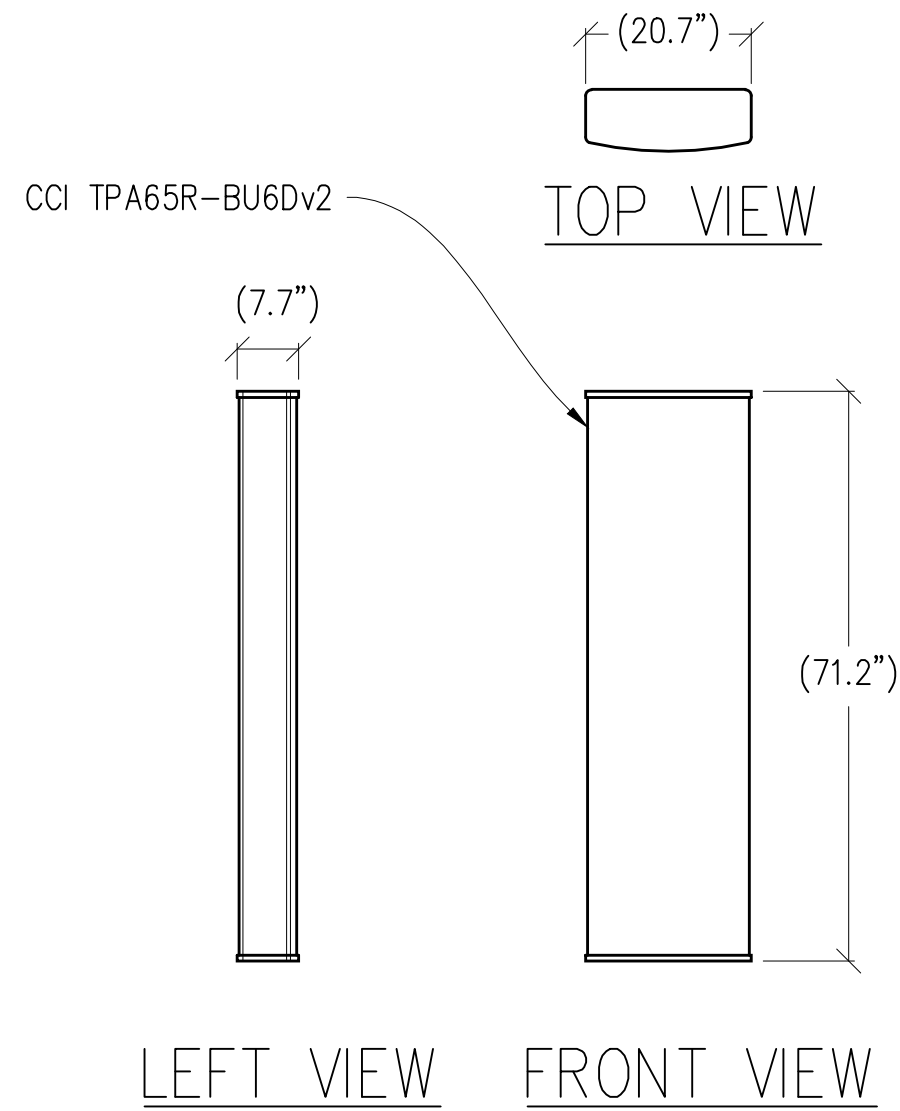


2 ANTENNA DETAIL
1/2"=1'-0" MAX WEIGHT: 80.9 LBS

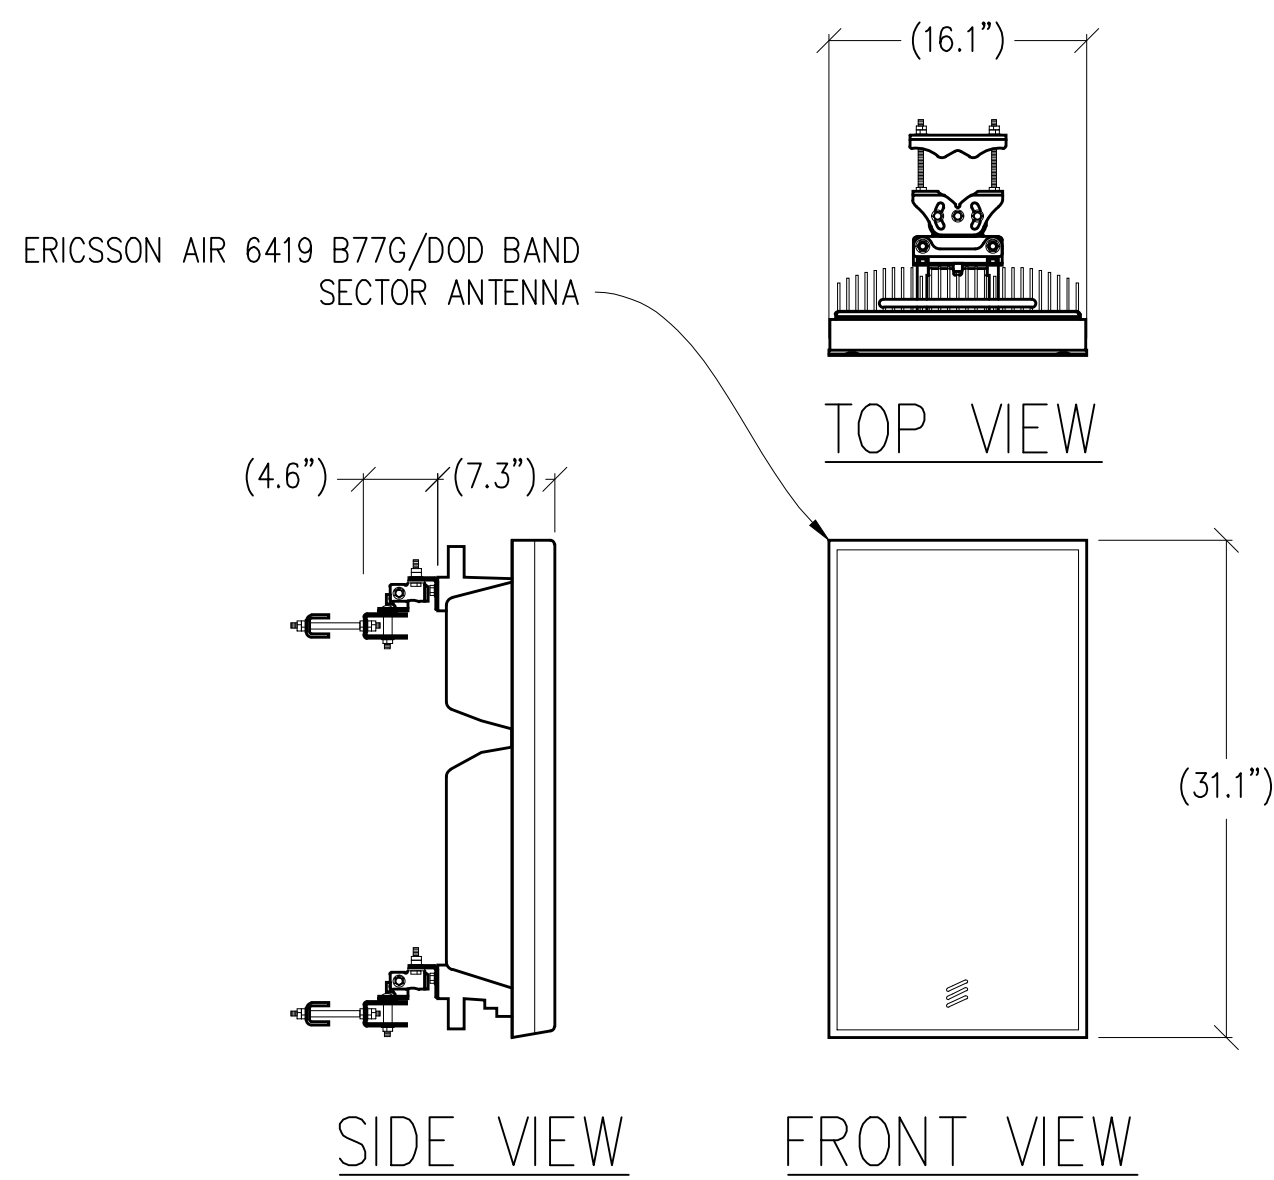


3 ANTENNA DETAIL
1"=1'-0" MAX WEIGHT: 55.4 LBS

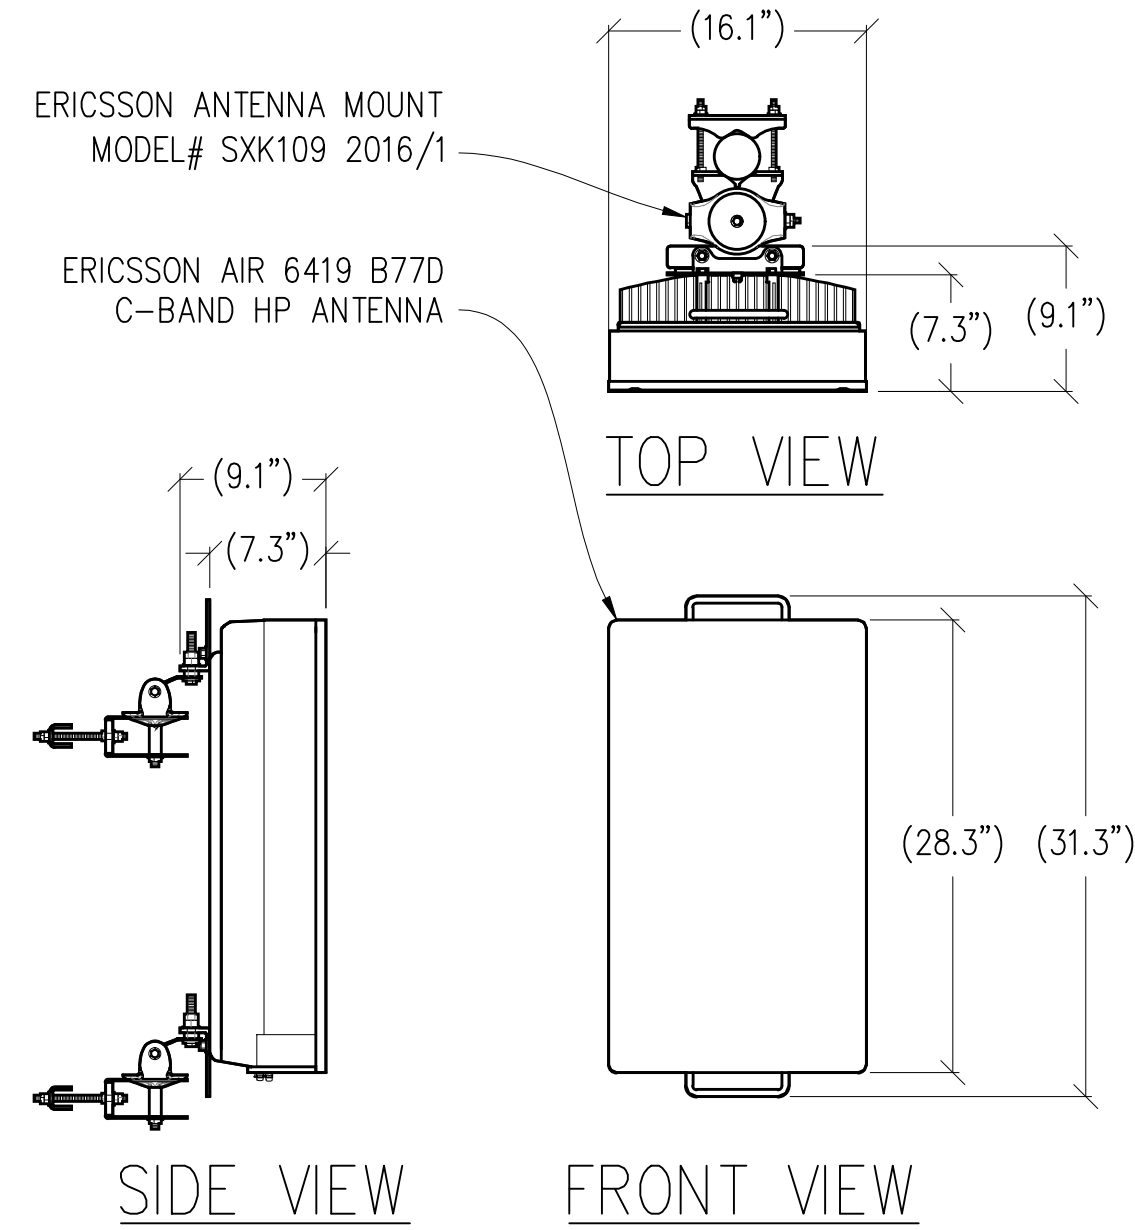


4 ANTENNA DETAIL
1"=1'-0" MAX WEIGHT: 64 LBS

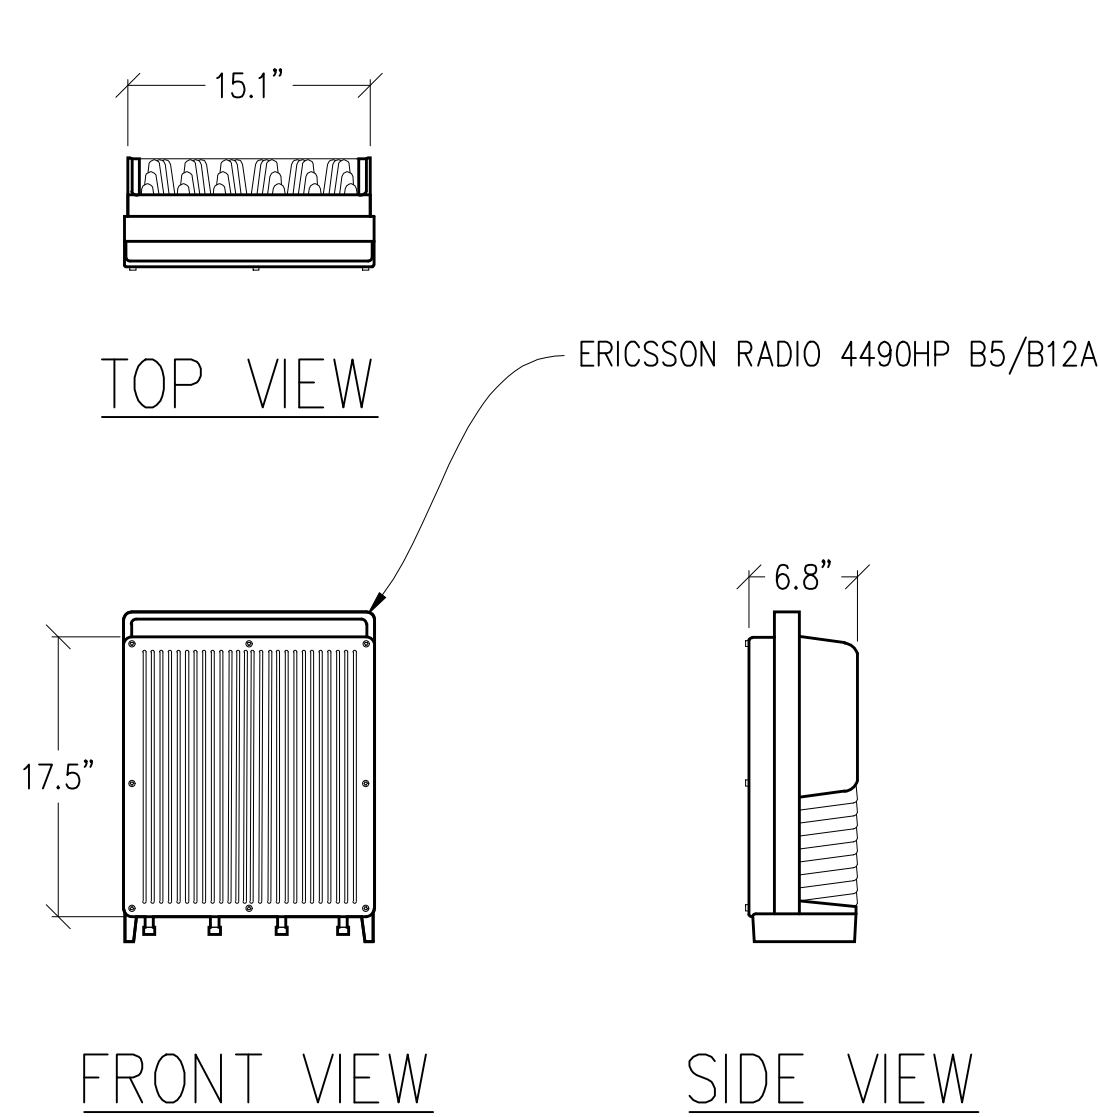


5 RADIO 4490HP DETAIL
1"=1'-0" MAX WEIGHT: 68 LBS

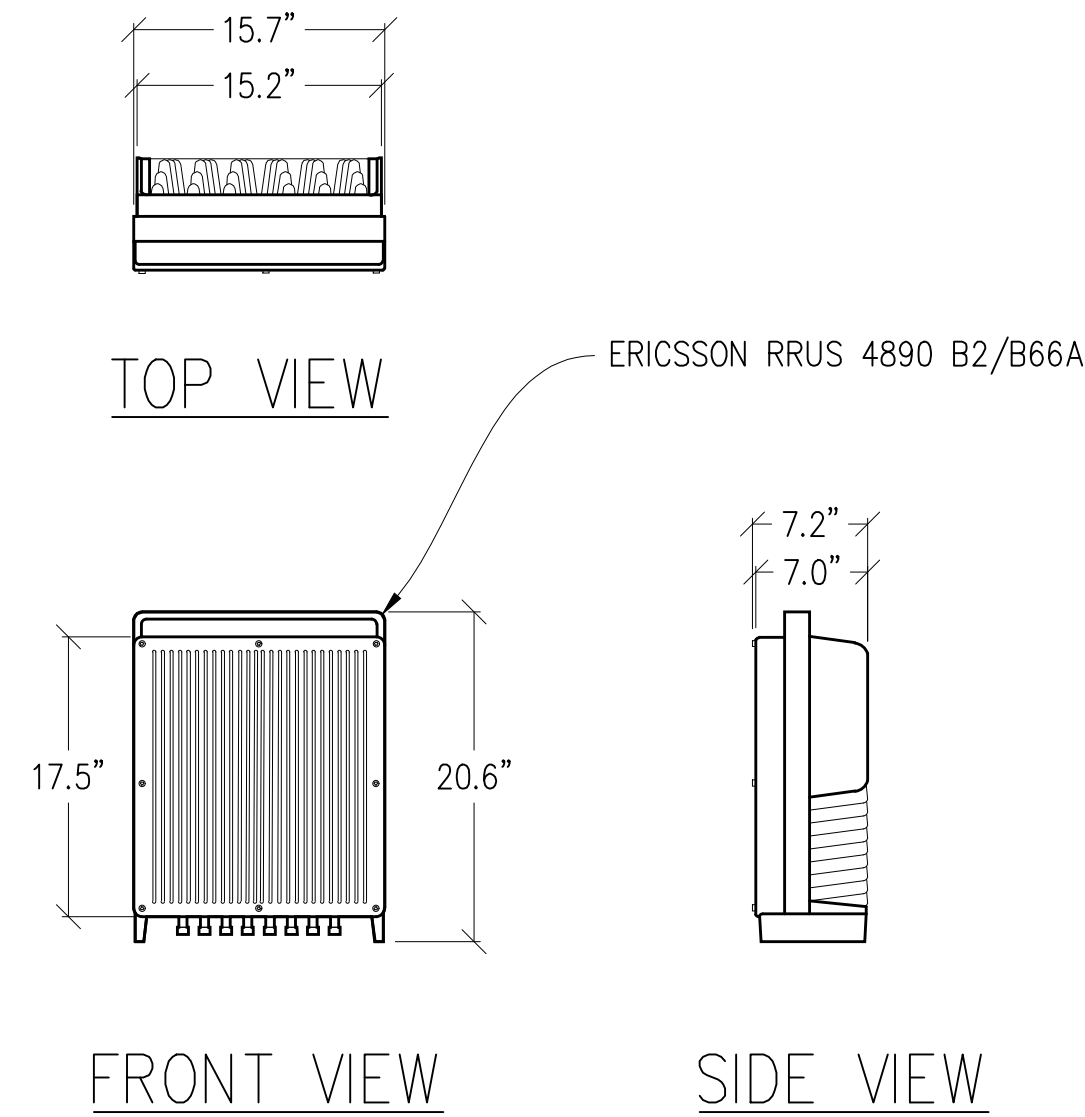

6 RADIO 4890HP DETAIL
1"=1'-0" MAX WEIGHT: 68 LBS

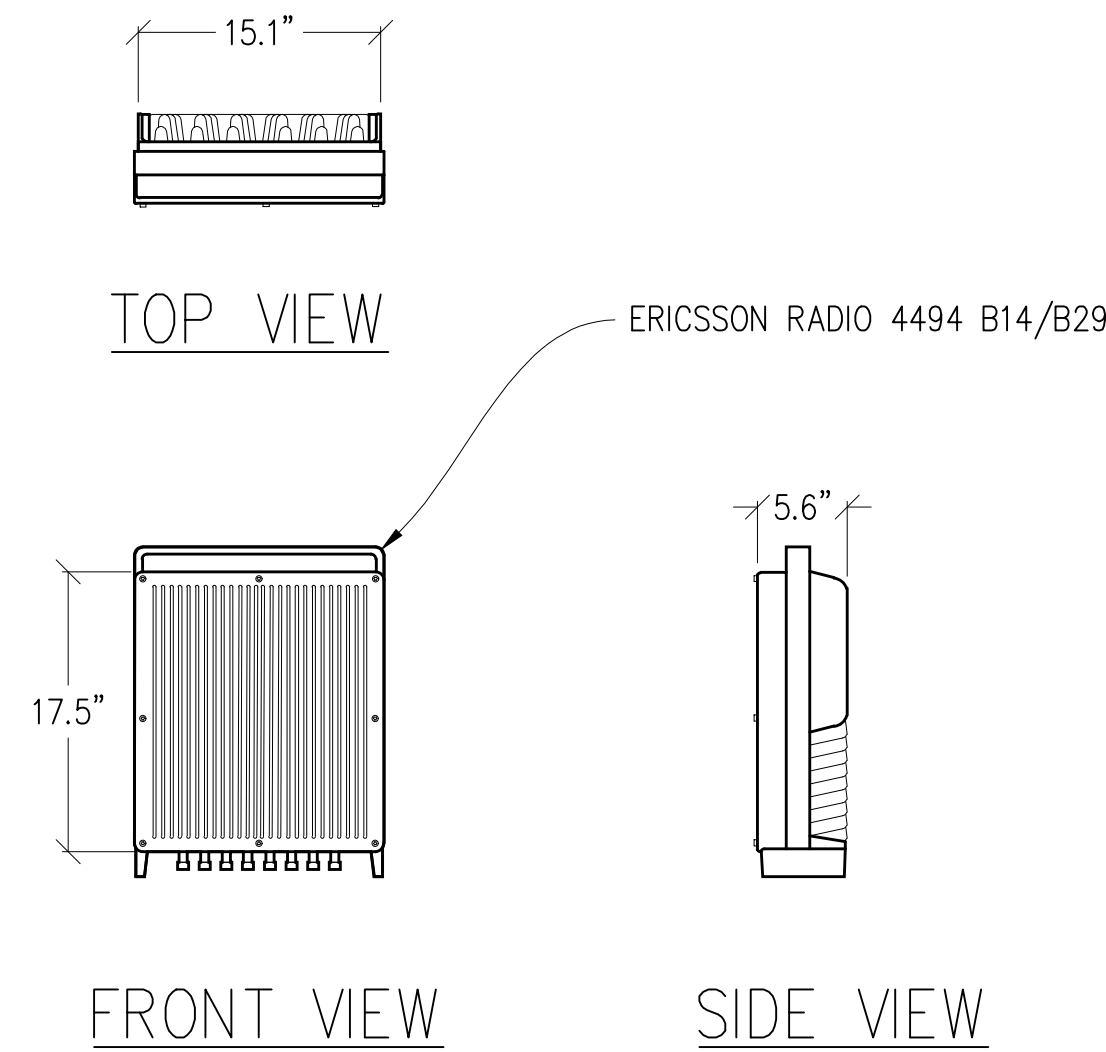

7 RADIO 4494 DETAIL
1"=1'-0" MAX WEIGHT: 57.3 LBS

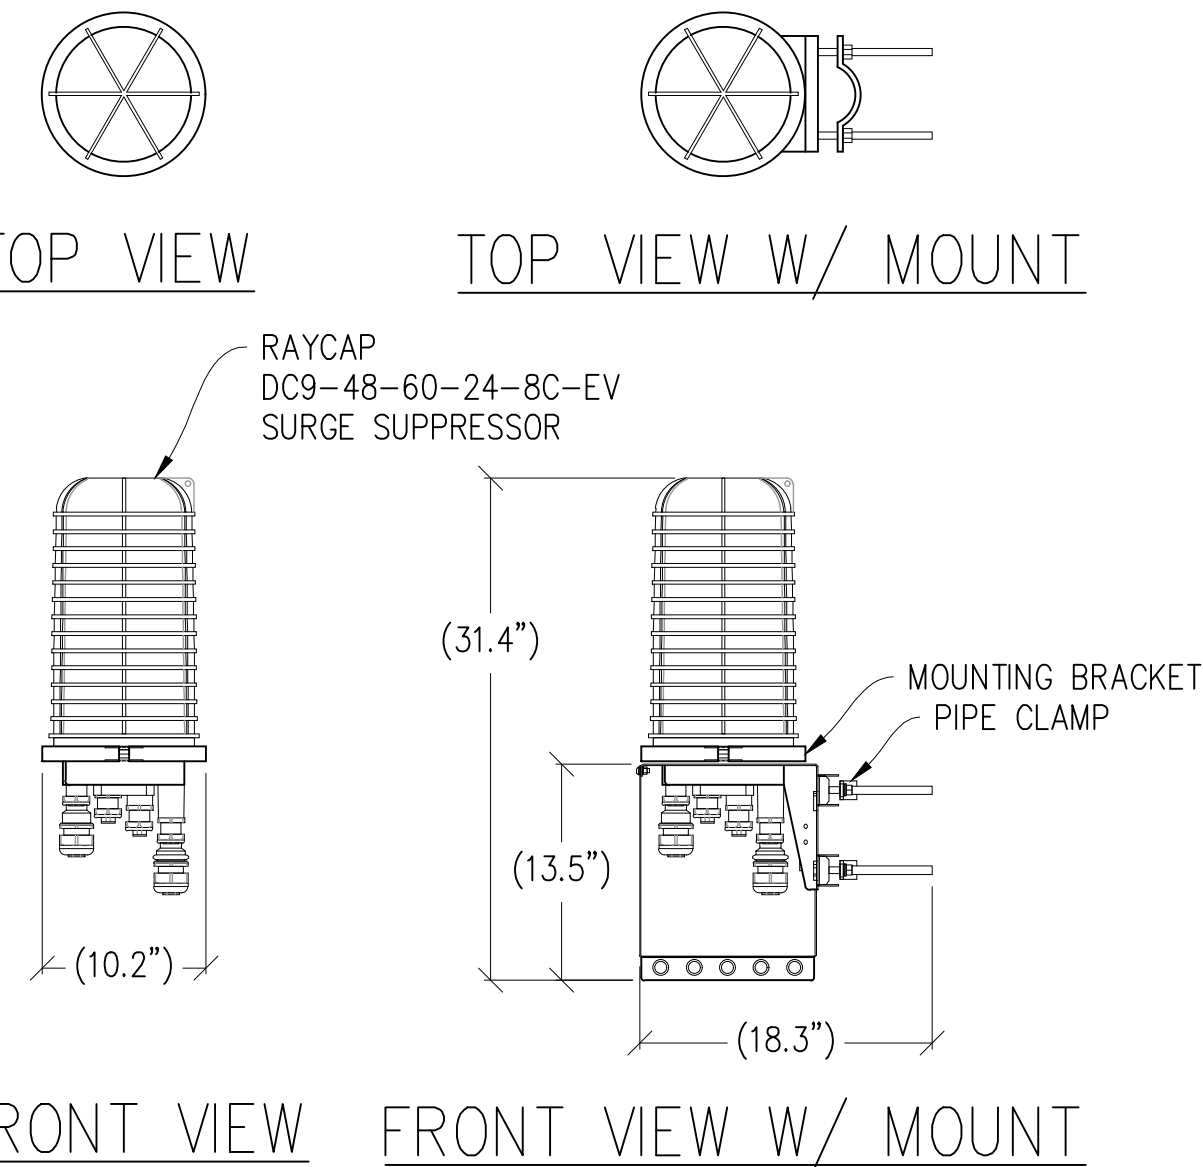

8 SURGE SUPPRESSOR DETAIL
1"=1'-0" MAX WEIGHT = 26.2 LBS

Issued For:

CCL06126
CCL06126

3111 BENTON STREET
SANTA CLARA, CA 95051

PREPARED FOR



5001 Executive Parkway
San Ramon, California 94583

Vendor:



AT&T SITE NO: CCL06126

PROJECT NO: -

DRAWN BY: T.T.

CHECKED BY: J. GRAY

APPROVED BY: -

ISSUE STATUS

REV	DATE	DESCRIPTION	CAD
0	11/15/24	ZD 90%	T.T.

Licensee:

PRELIMINARY:
NOT FOR
CONSTRUCTION

KEVIN R. SORENSEN
S4469

IT IS A VIOLATION OF LAW FOR ANY PERSON,
UNLESS THEY ARE ACTING UNDER THE
DIRECTION OF A LICENSED PROFESSIONAL
ENGINEER, TO ALTER THIS DOCUMENT.

ENGINEER:




SHEET TITLE:

ANTENNA
DETAILS

SHEET NUMBER:

A-4.1

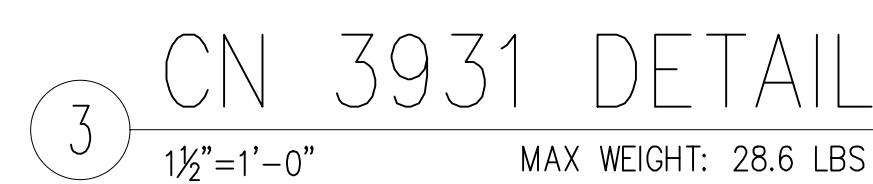

A-4.2

E-1.1